

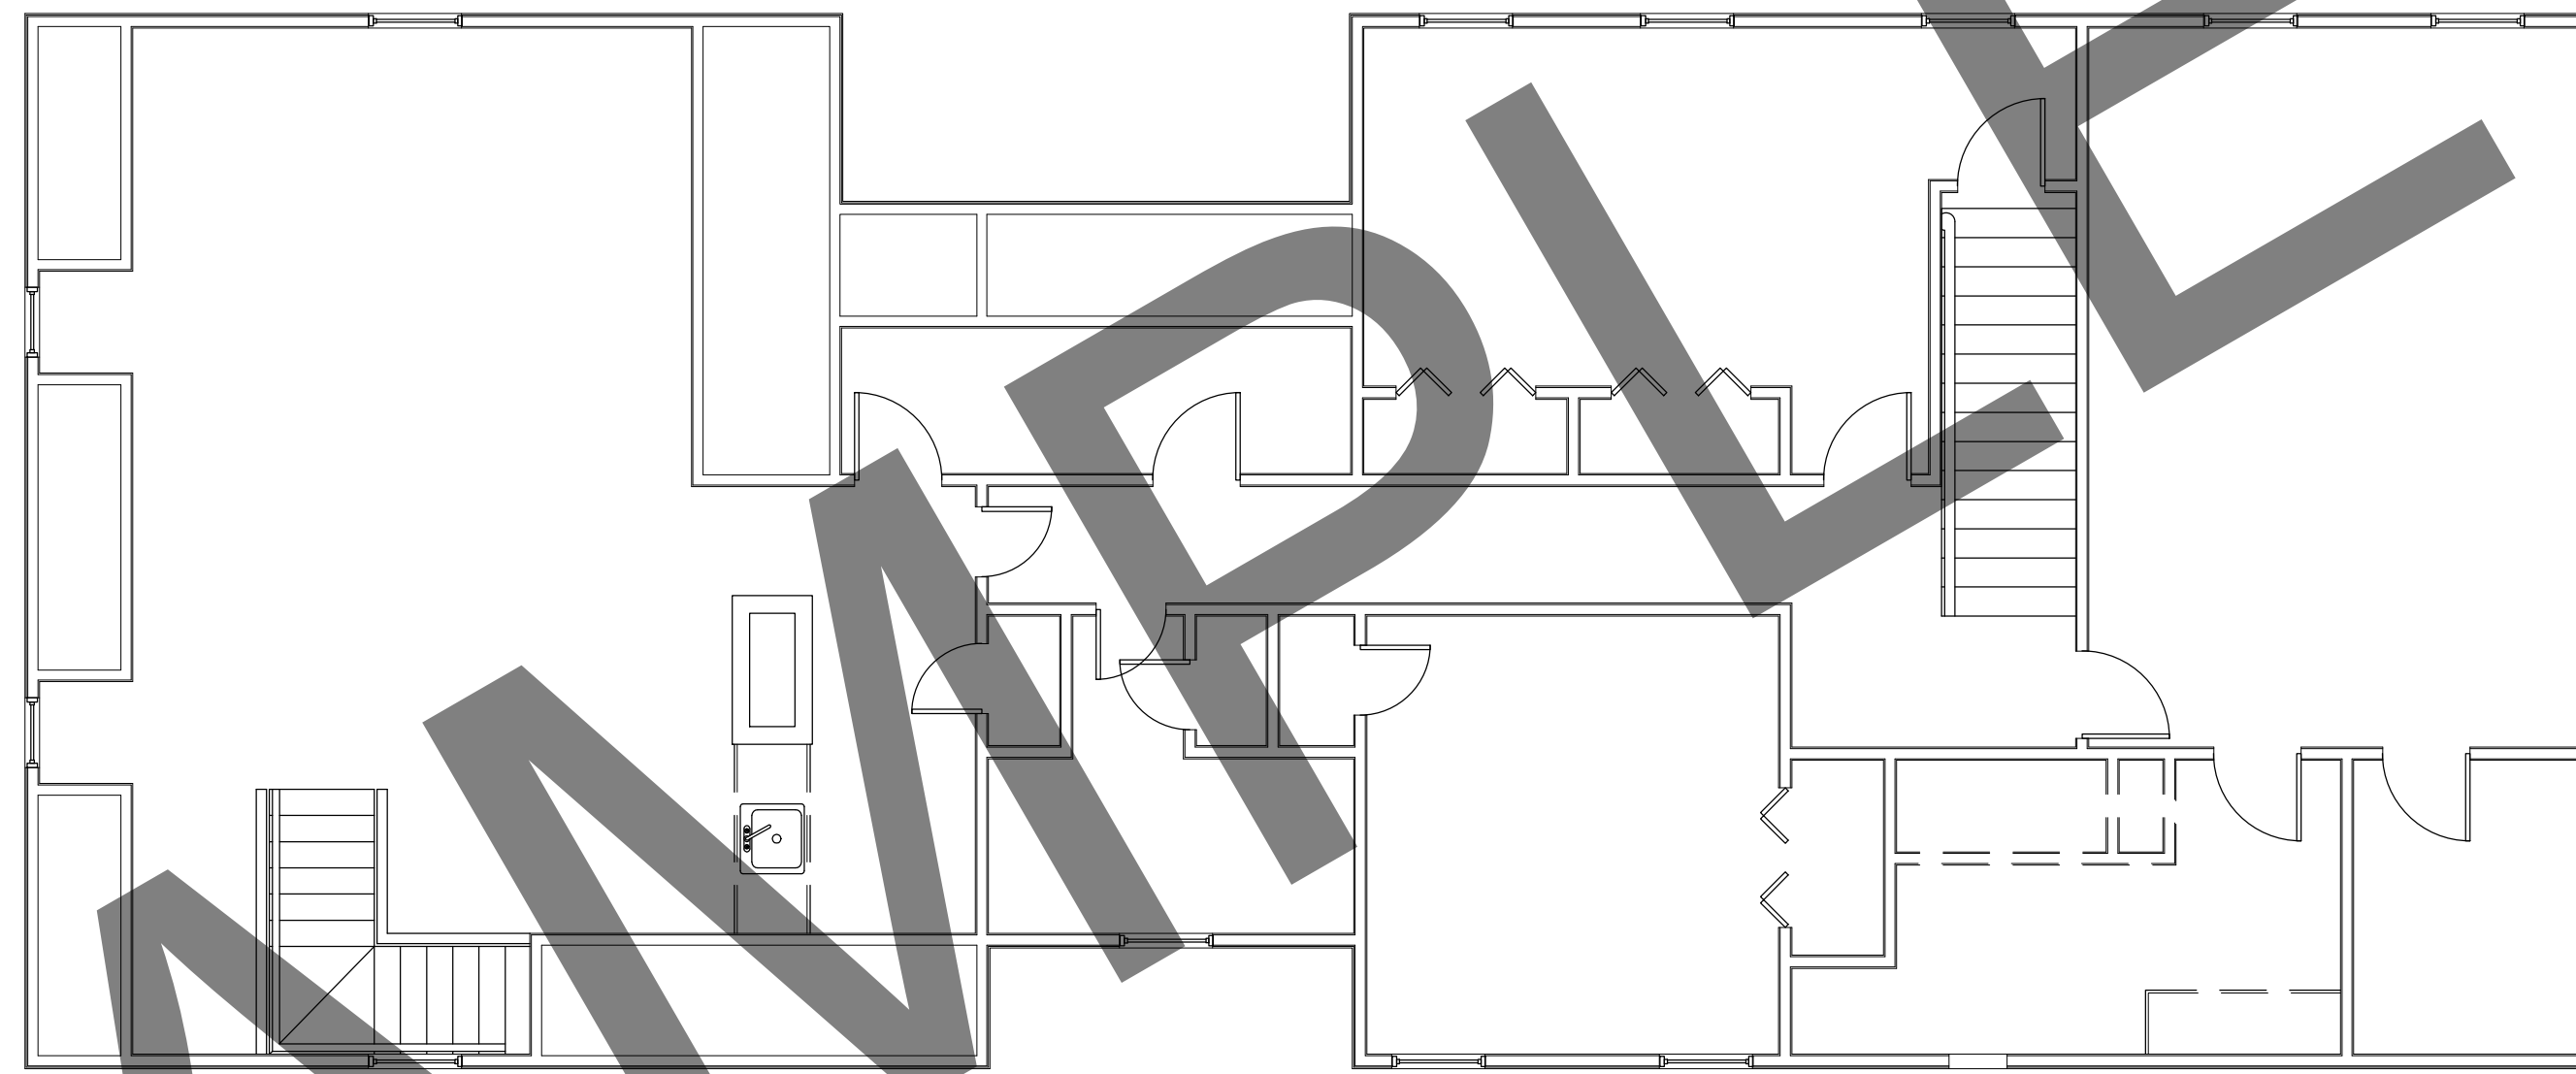
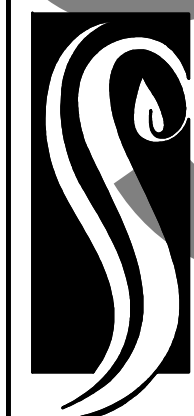


1
AD-101 DEMO / EXISTING SECOND FLOOR PLAN
Scale: 3/16 = 1'-0"

 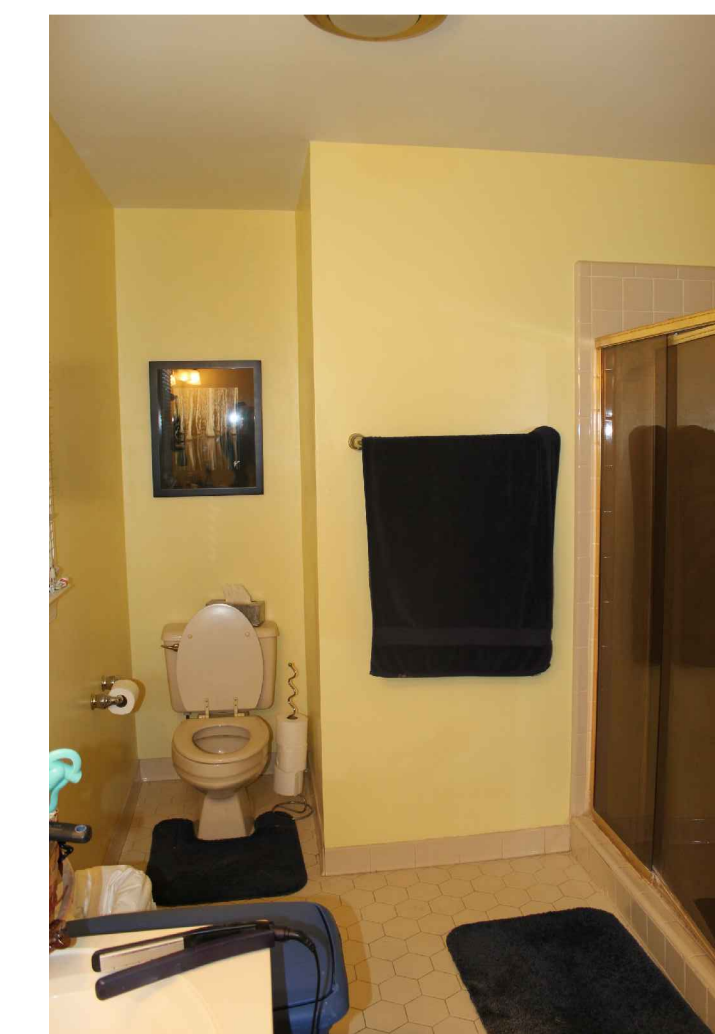


2
AD-101 DEMO / EXISTING SECOND FLOOR PLAN
Scale: 3/16 = 1'-0"

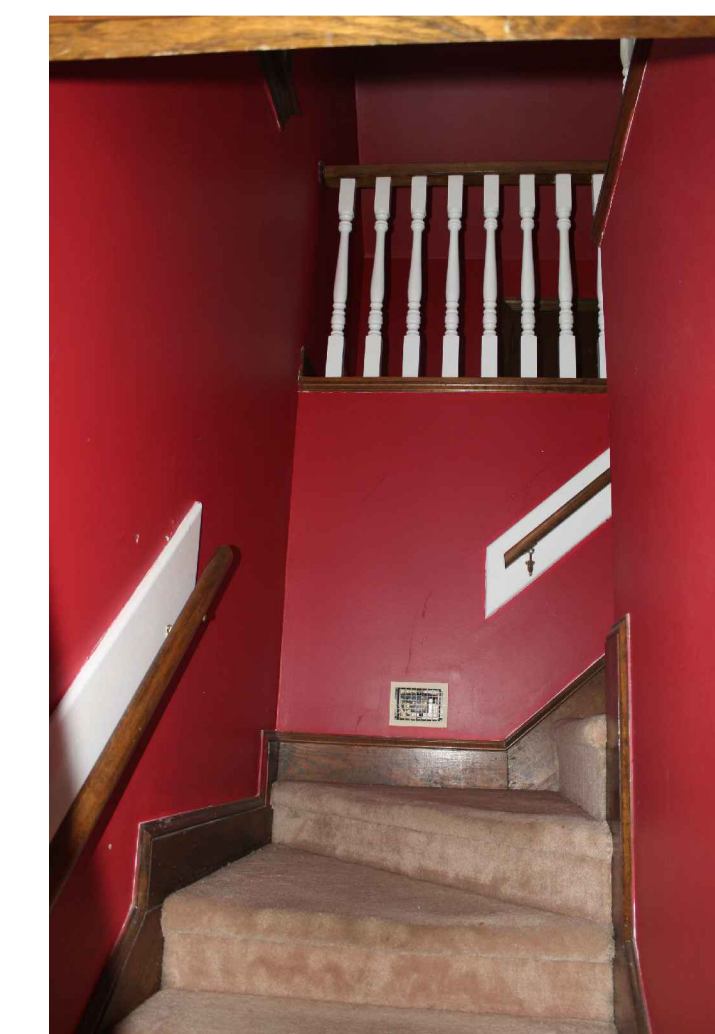

**GO ARCHITECTURAL
DESIGN, PLLC**
1202-A Pollock St., New Bern, NC 28560
(252)633-0322 Tel www.GOarchdesign.com


COPYRIGHT NOTE:
THESE PLANS ARE THE PROPERTY OF THE ARCHITECT.
THESE PLANS CONTAIN PROPRIETARY INFORMATION OF
GO ARCHITECTURAL DESIGN, PLLC. THEY ARE SUBJECT
TO FEDERAL COPYRIGHT AND OTHER APPLICABLE
FEDERAL AND STATE PROPERTY, TRADE AND RELATED
LAWS. THESE PLANS, INCLUDING THE INFORMATION
CONTAINED WITHIN, SHALL NOT BE SHARED,
REPRODUCED, DISTRIBUTED OR USED IN ANY WAY
WITHOUT WRITTEN CONSENT FROM THE ARCHITECT.
ANY FAILURE TO OBTAIN SUCH CONSENT IS A VIOLATION
OF LAW AND MAY BE SUBJECT TO CIVIL AND CRIMINAL
PROSECUTION AND PENALTIES.




Date: 05.13.2016
Revisions:

RESIDENCE
NEW BERN, NC 28560

AD-101
DEMO/EXISTING
12 X 18 SHEETS ARE HALF SIZE

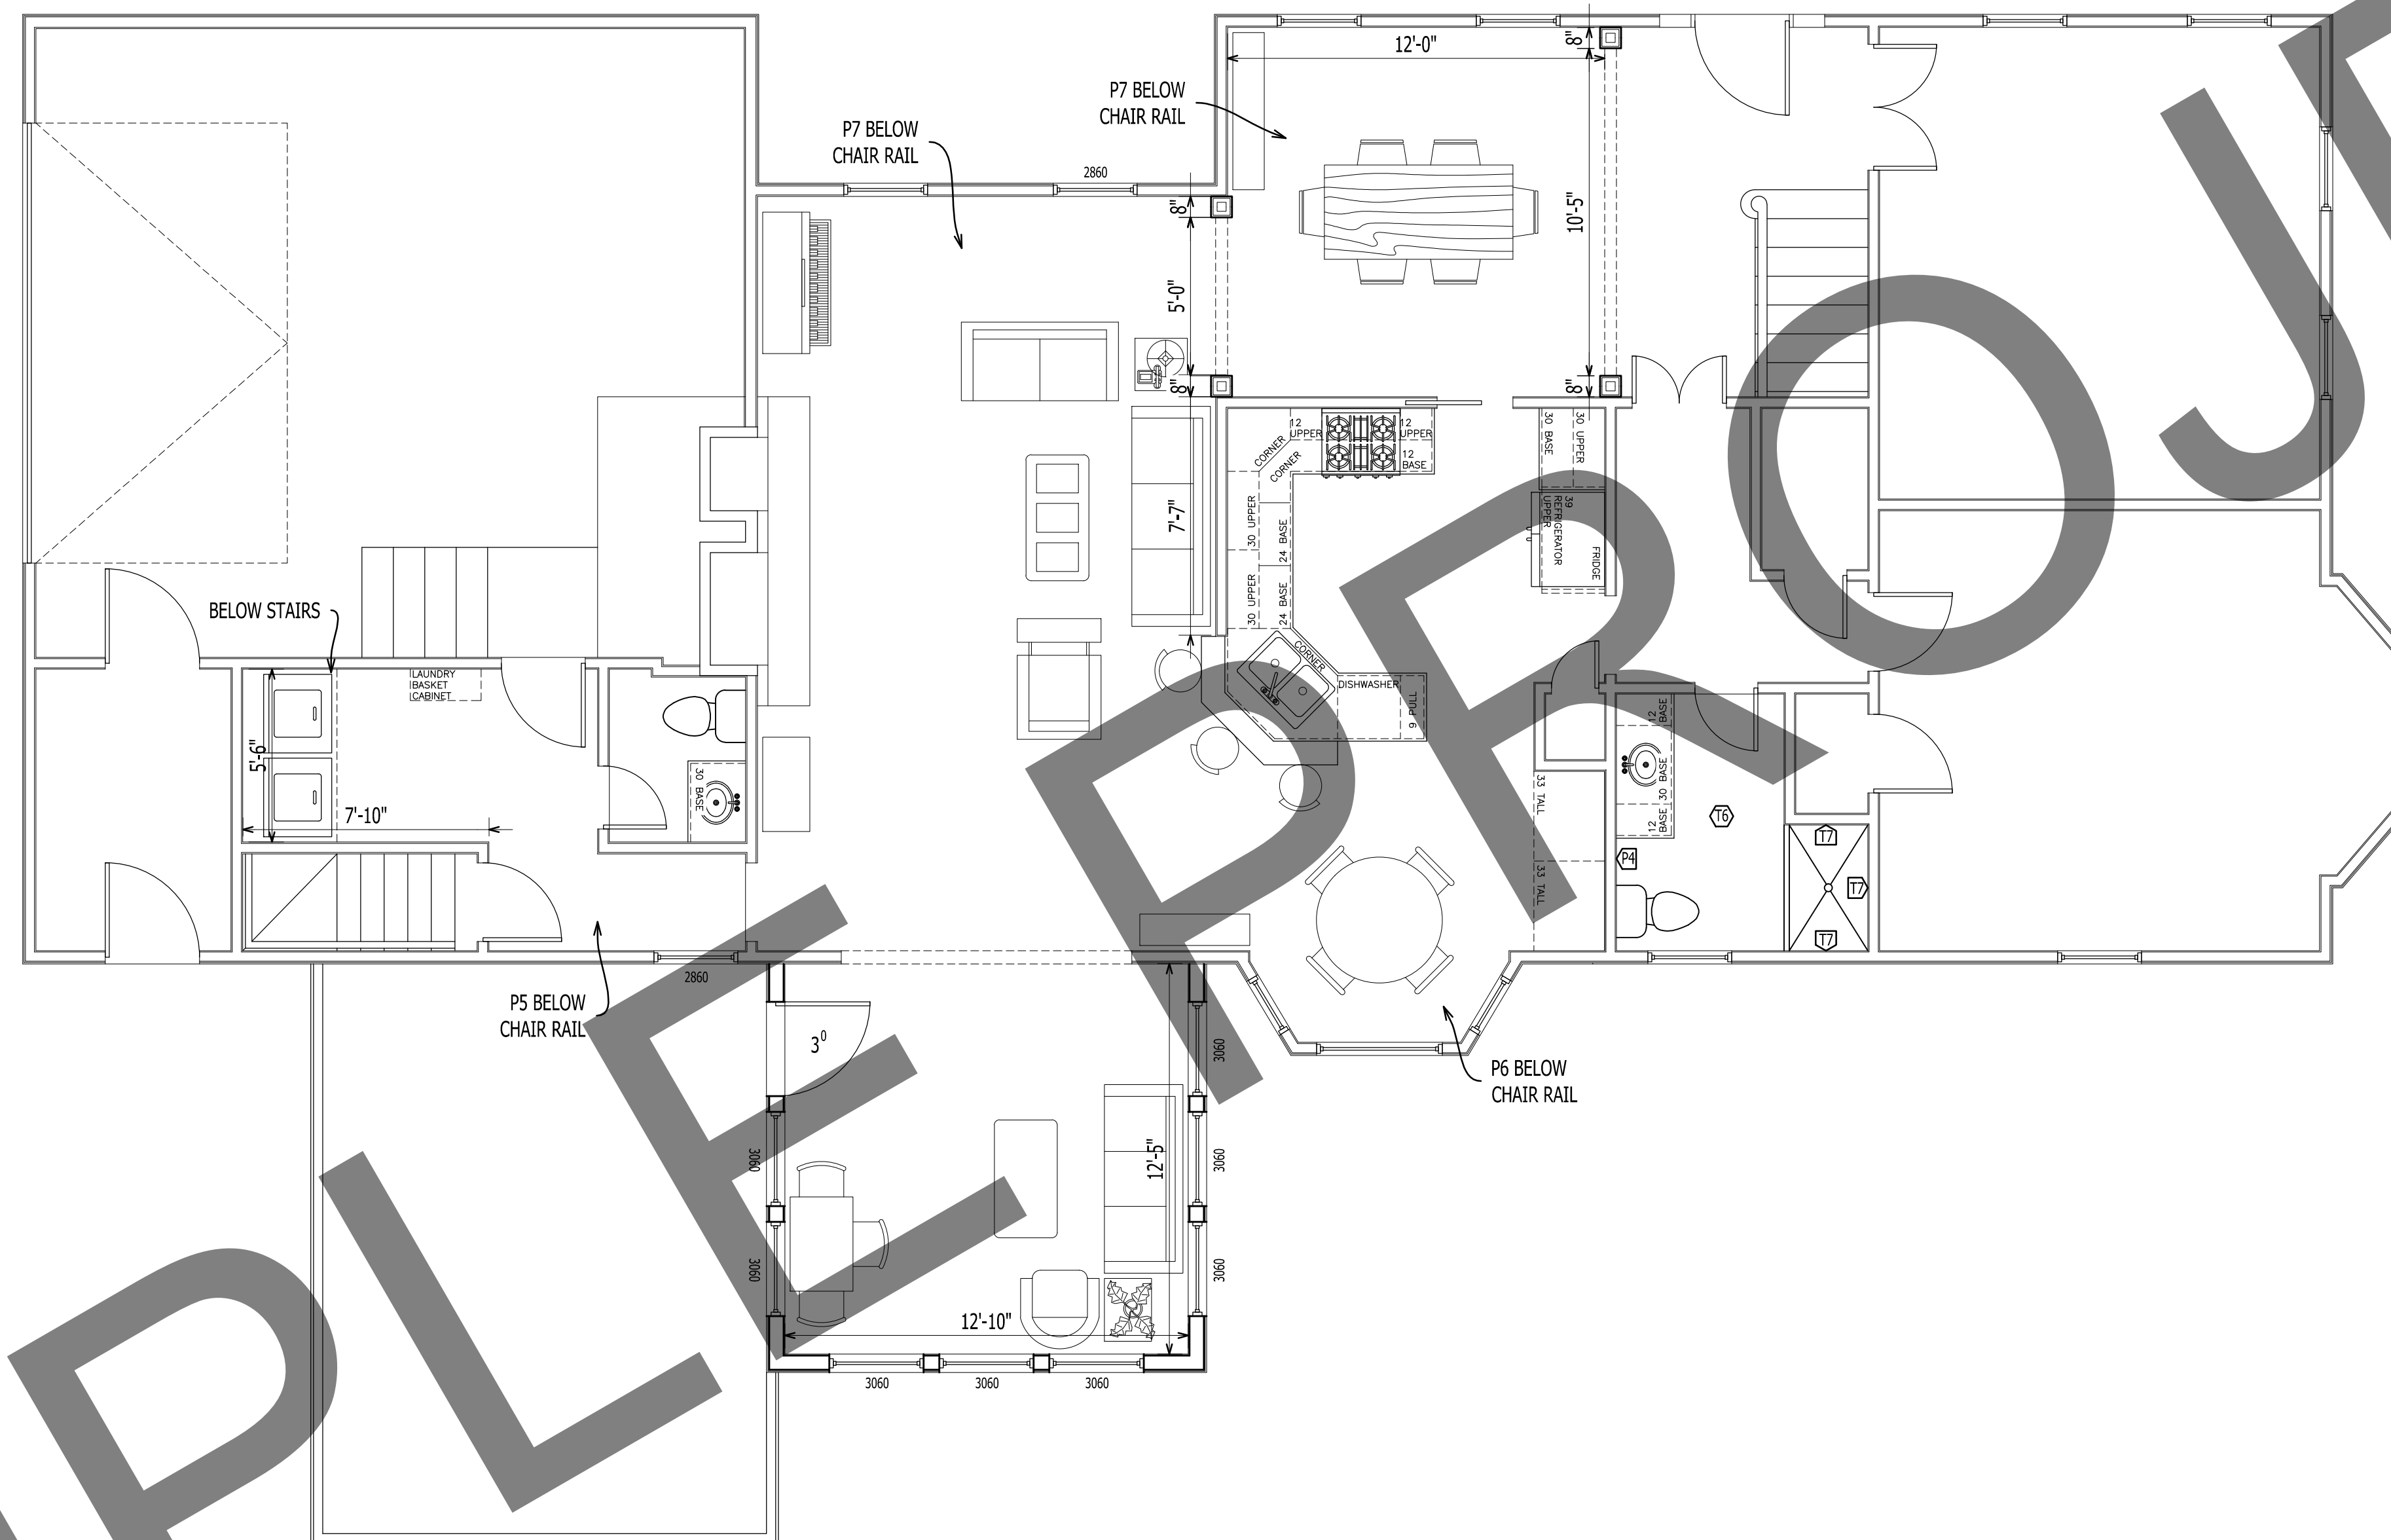

1 FIRST FLOOR INTERIOR FINISHES
 A-101 Scale: 1/4" = 1'-0"

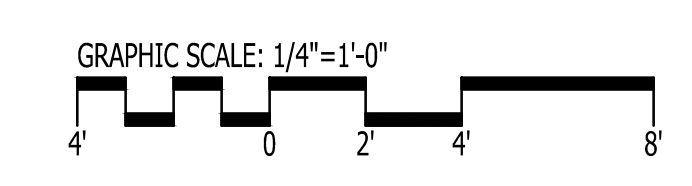

GO ARCHITECTURAL DESIGN, PLLC
 1202-A Pollock St., New Bern, NC 28560
 (252)633-0322 Tel www.GOarchdesign.com


COPYRIGHT NOTE:
 THESE PLANS ARE THE PROPERTY OF THE ARCHITECT. THESE PLANS CONTAIN PROPRIETARY INFORMATION OF GO ARCHITECTURAL DESIGN, PLLC. THEY ARE SUBJECT TO FEDERAL COPYRIGHT AND OTHER APPLICABLE FEDERAL AND STATE PROPERTY, TRADE AND RELATED LAWS. THESE PLANS, INCLUDING THE INFORMATION CONTAINED WITHIN, SHALL NOT BE SHARED, REPRODUCED, DISTRIBUTED OR USED IN ANY WAY WITHOUT WRITTEN CONSENT FROM THE ARCHITECT. ANY FAILURE TO OBTAIN SUCH CONSENT IS A VIOLATION OF LAW AND MAY BE SUBJECT TO CIVIL AND CRIMINAL PROSECUTION AND PENALTIES.

Date: 05.13.2016
 Revisions:


RESIDENCE
 NEW BERN, NC 28560

A-101
 NEW PLAN
 12 X 18 SHEETS ARE HALF SIZE

SAMPLE PROJECT

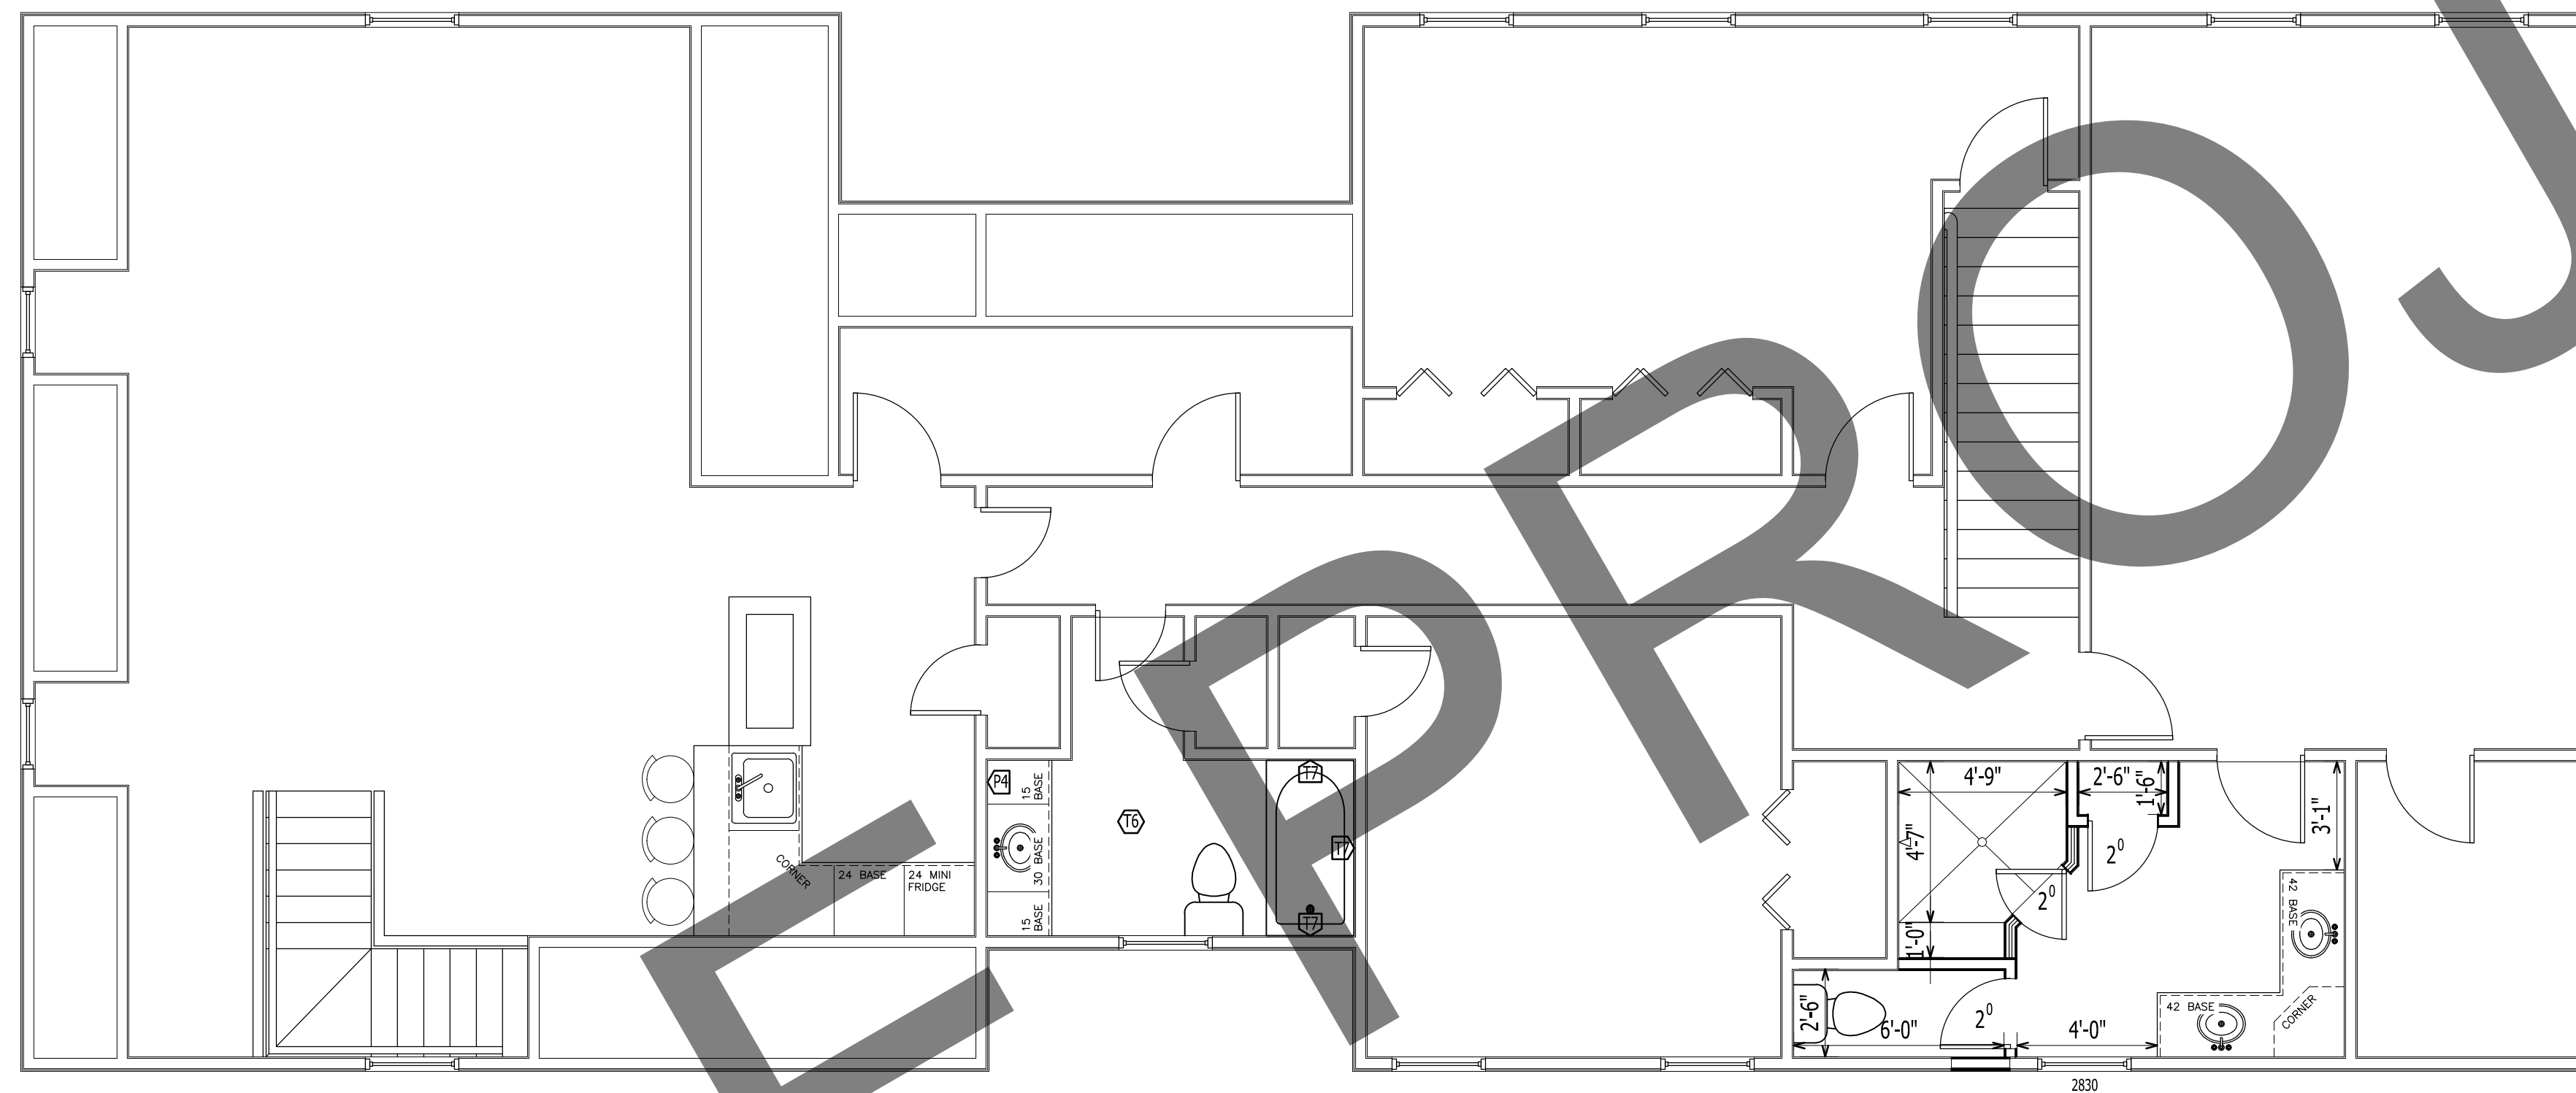

1 SECOND FLOOR INTERIOR FINISHES
A-102 Scale: 1/4" = 1'-0"

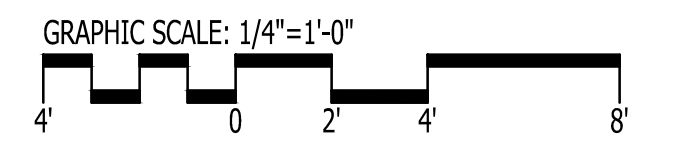


 **GO ARCHITECTURAL
DESIGN, PLLC**
1202-A Pollock St., New Bern, NC 28560
(252)633-0322 Tel www.GOarchdesign.com

COPYRIGHT NOTE:
THESE PLANS ARE THE PROPERTY OF THE ARCHITECT.
THESE PLANS CONTAIN PROPRIETARY INFORMATION OF
GO ARCHITECTURAL DESIGN, PLLC. THEY ARE SUBJECT
TO FEDERAL COPYRIGHT AND OTHER APPLICABLE
FEDERAL AND STATE PROPERTY, TRADE AND RELATED
LAWS. THESE PLANS, INCLUDING THE INFORMATION
CONTAINED WITHIN, SHALL NOT BE SHARED,
REPRODUCED, DISTRIBUTED OR USED IN ANY WAY
WITHOUT WRITTEN CONSENT FROM THE ARCHITECT.
ANY FAILURE TO OBTAIN SUCH CONSENT IS A VIOLATION
OF LAW AND MAY BE SUBJECT TO CIVIL AND CRIMINAL
PROSECUTION AND PENALTIES.


Date: 05.13.2016
Revisions:

RESIDENCE
NEW BERN, NC 28560


A-102
NEW PLAN
12 X 18 SHEETS ARE HALF SIZE

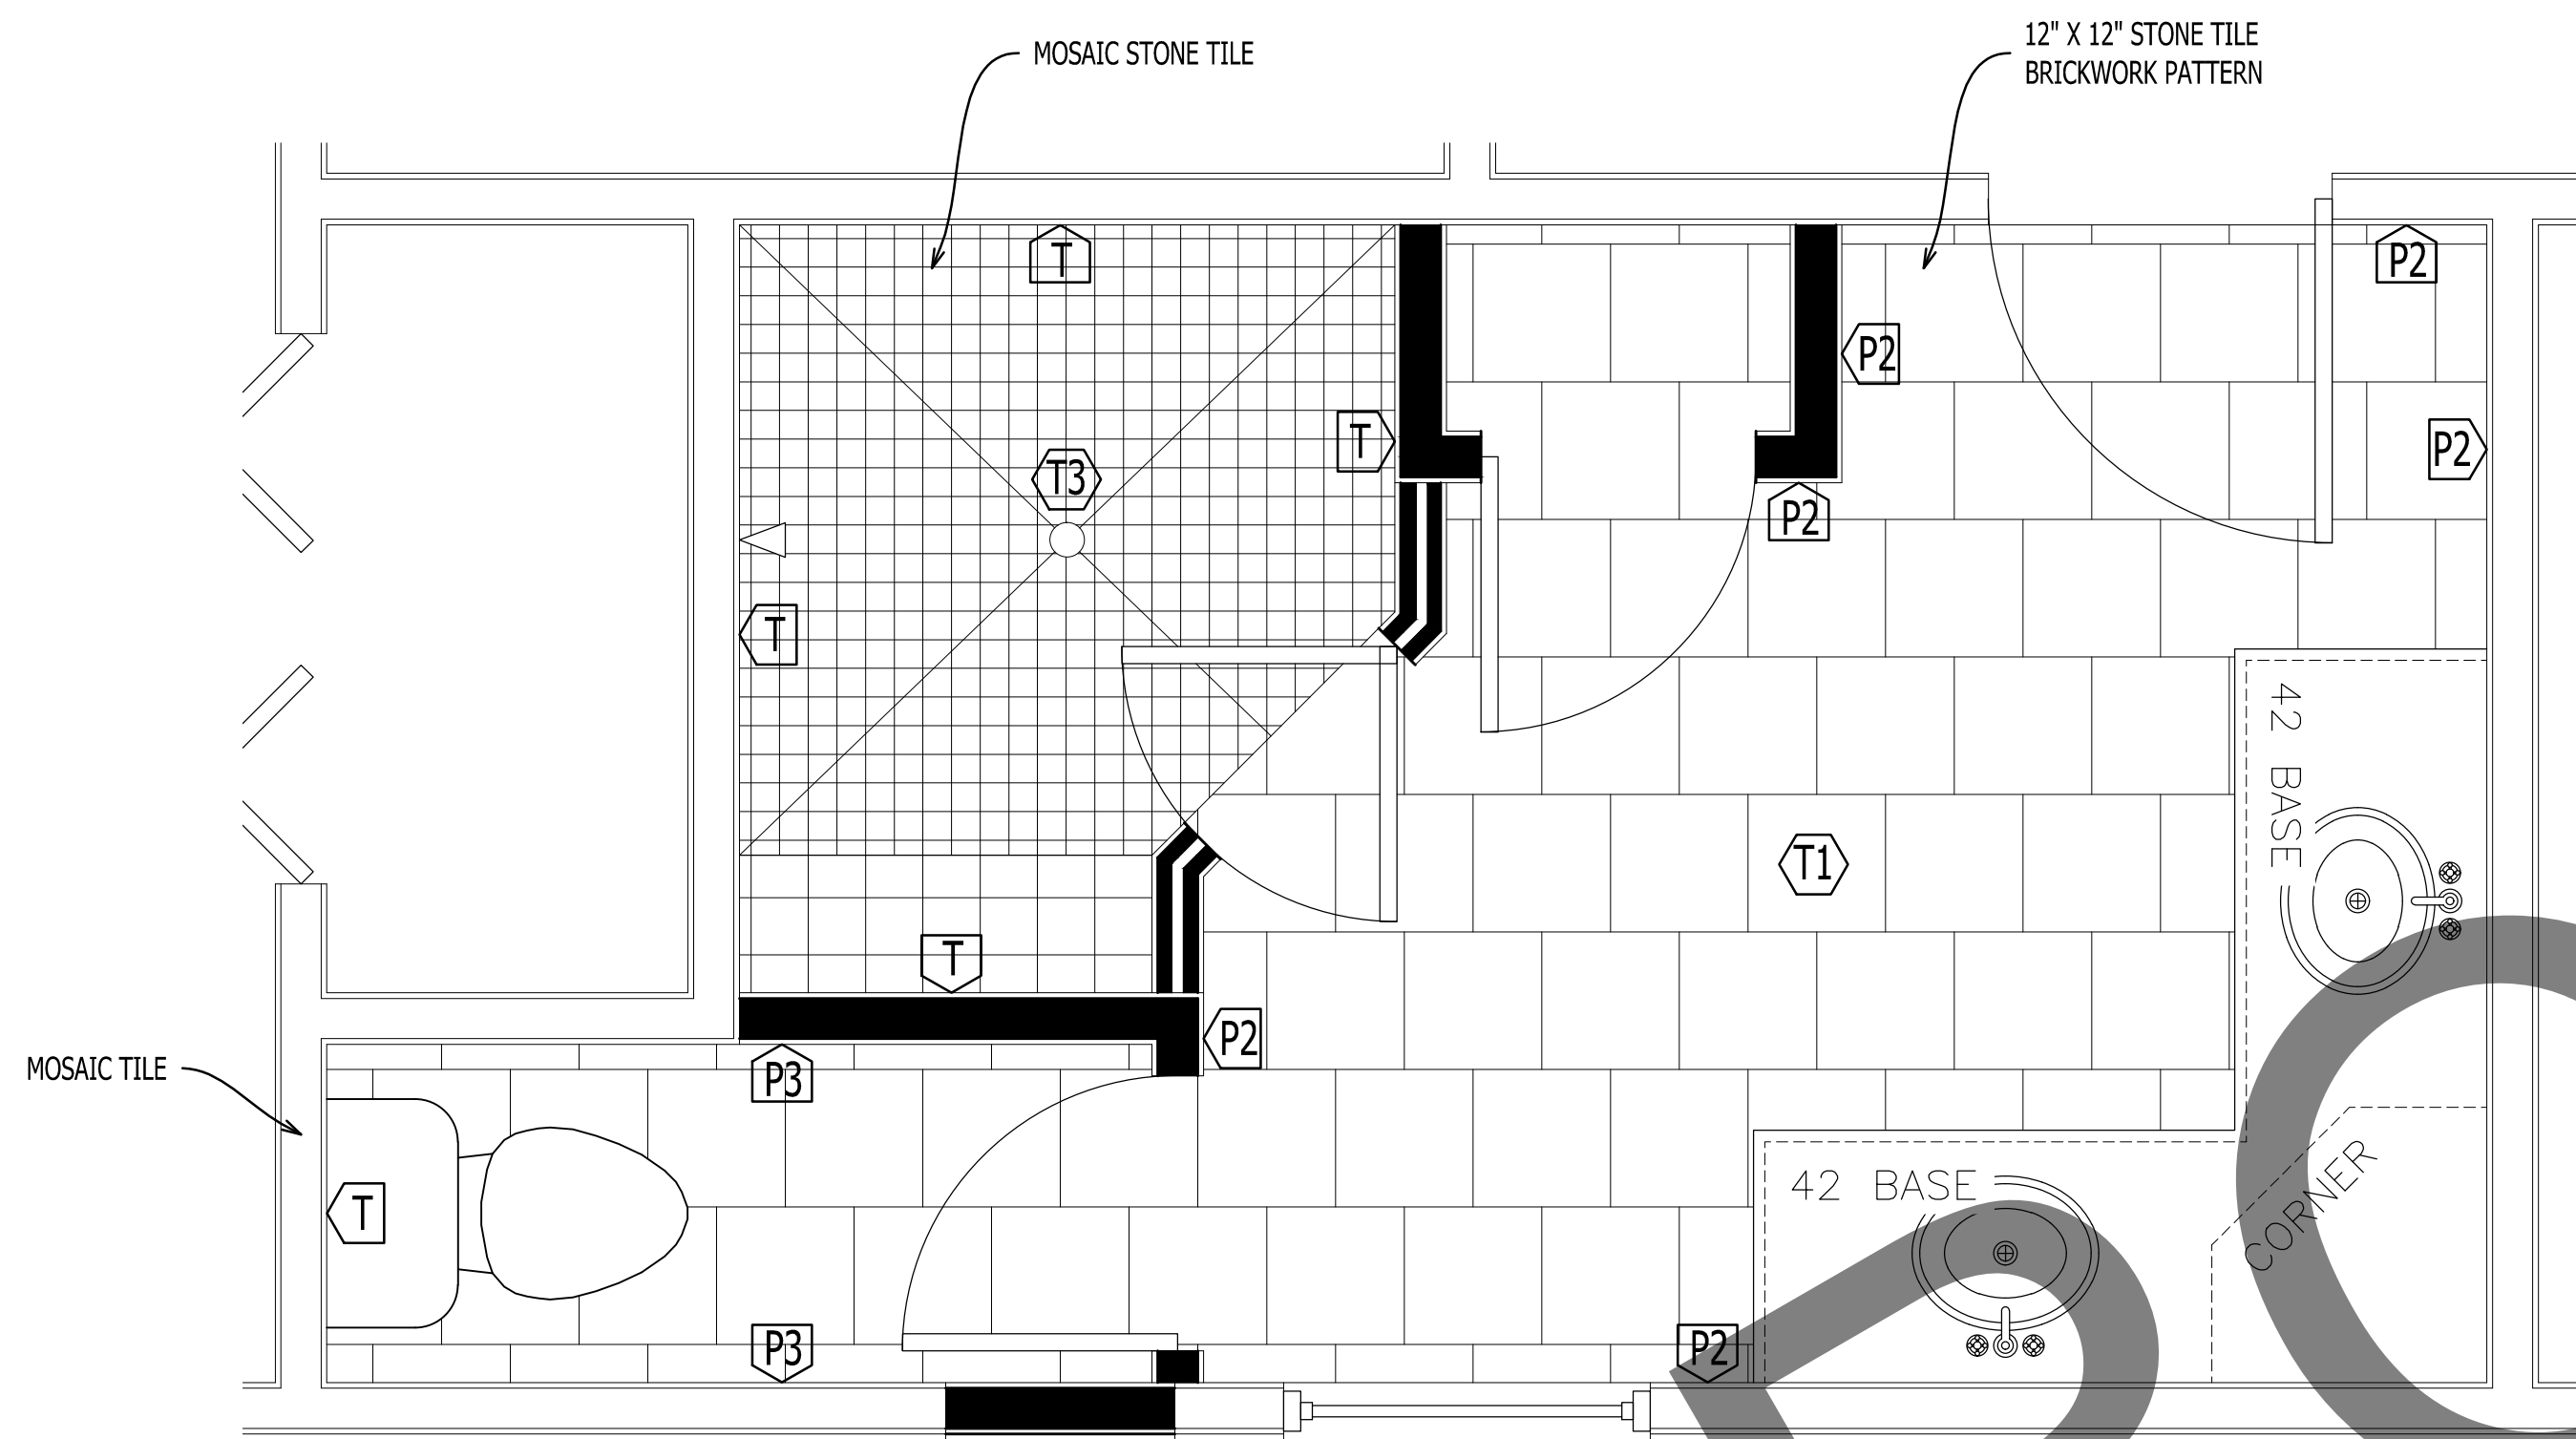


1
A-301 MASTER BATHROOM ENLARGED PLAN
Scale: 3/4" = 1'-0"

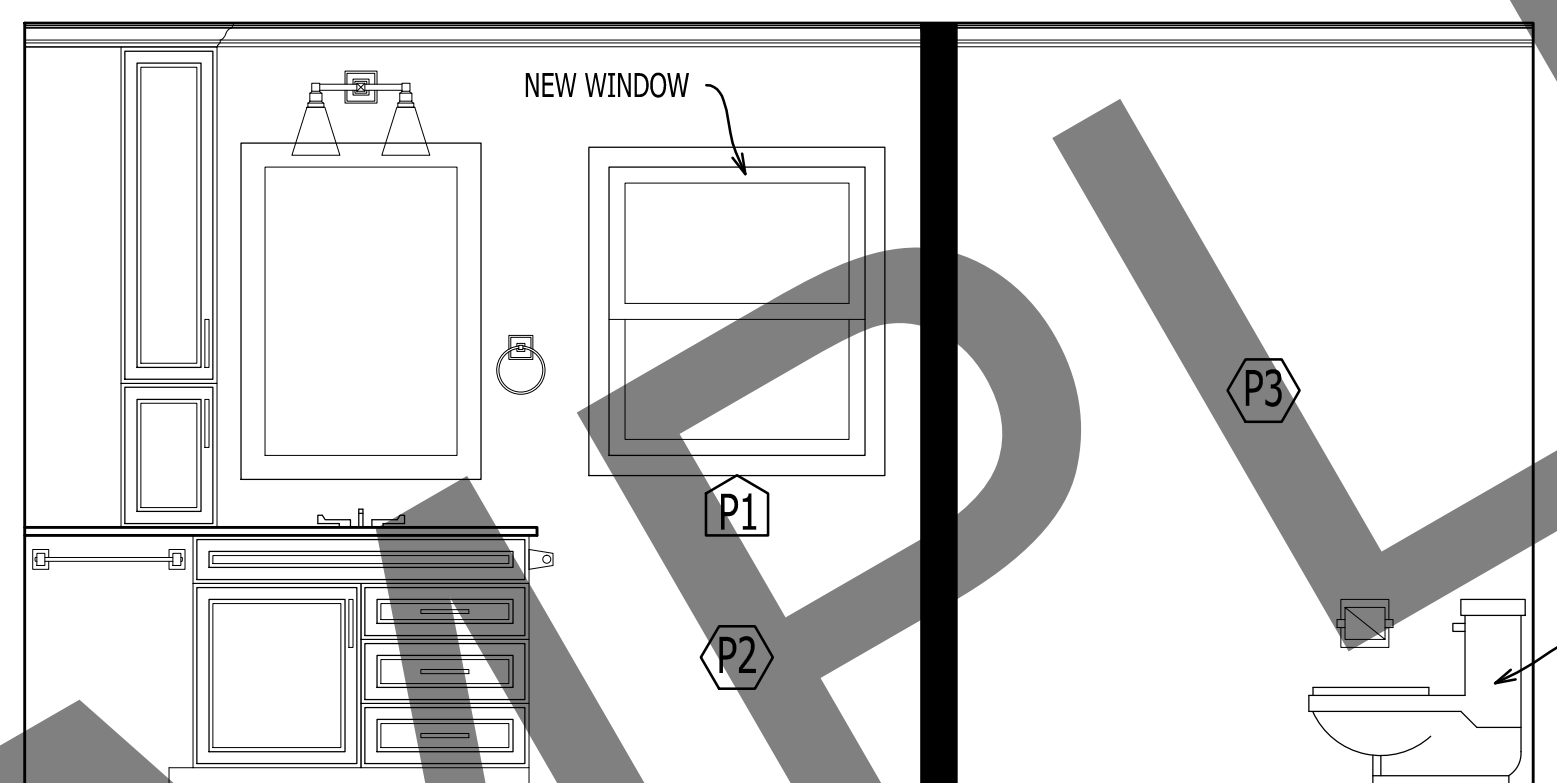


1
A-201 MASTER BATHROOM ELEVATION
Scale: 1/2" = 1'-0"

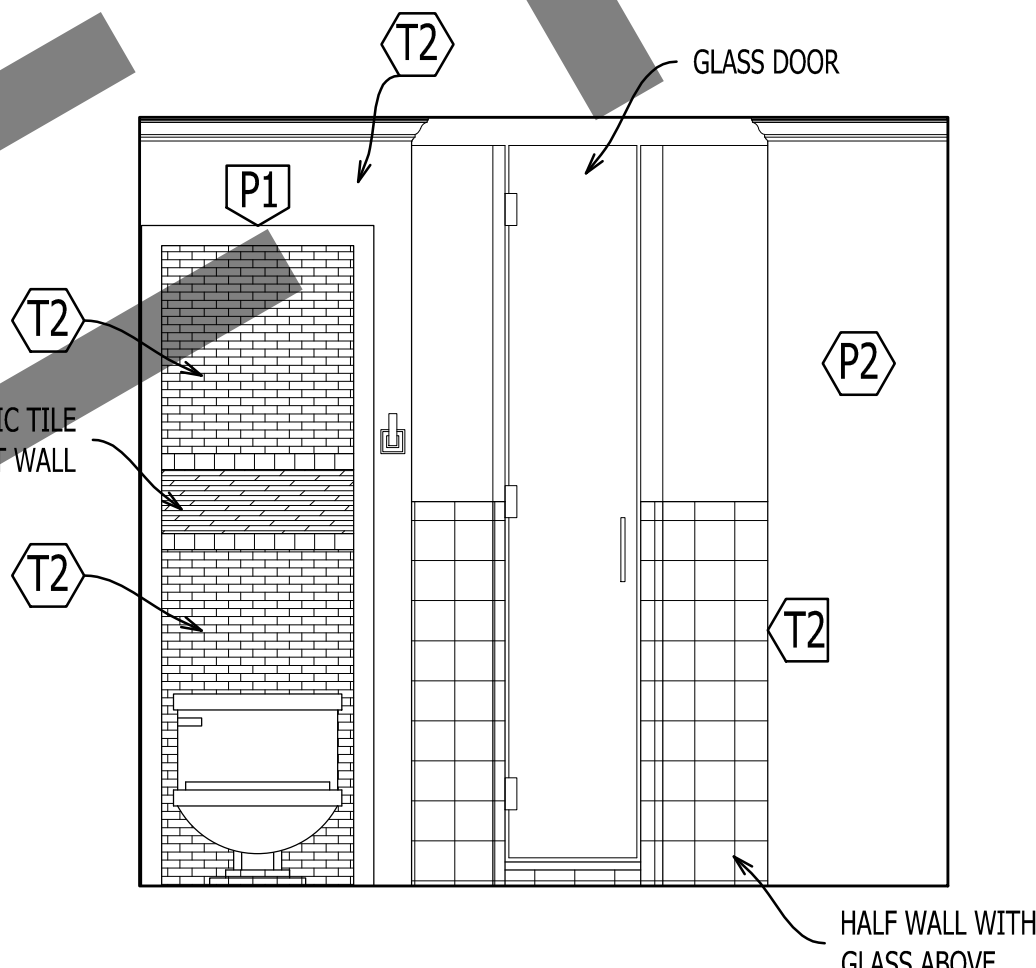


2
A-201 MASTER BATHROOM ELEVATION
Scale: 1/2" = 1'-0"

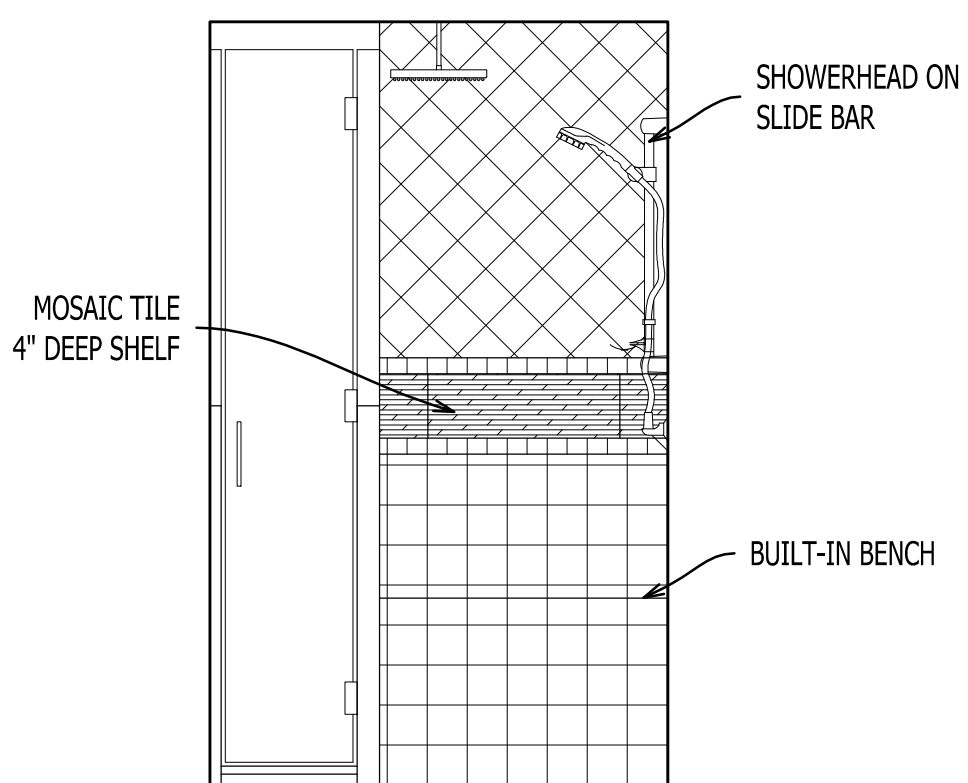


3
A-201 SHOWER ELEVATION
Scale: 1/2" = 1'-0"

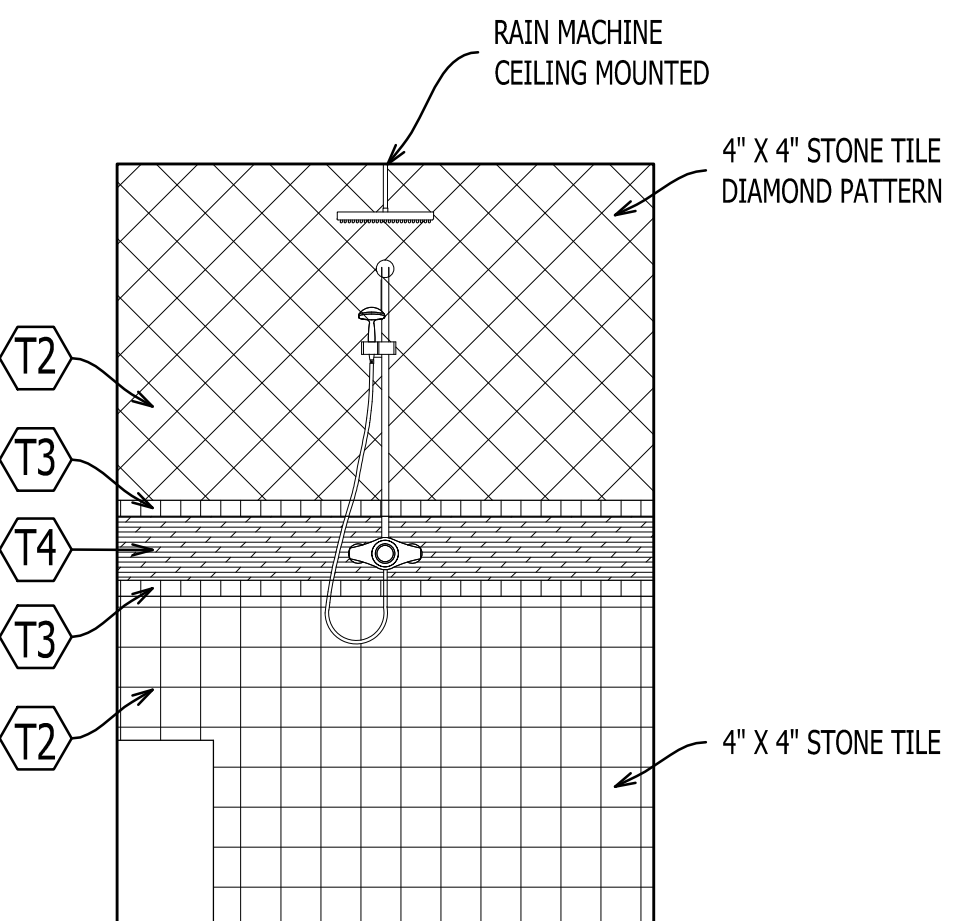


4
A-201 SHOWER ELEVATION
Scale: 1/2" = 1'-0"

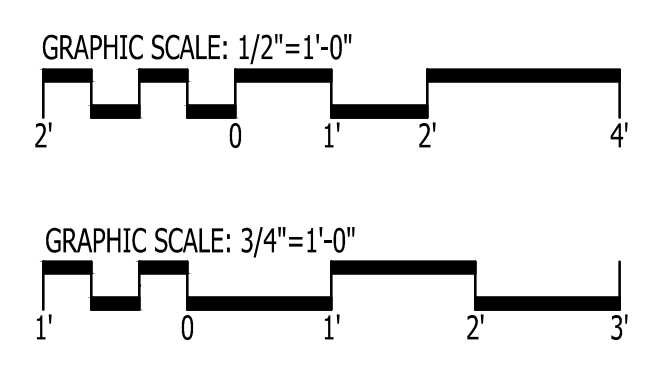


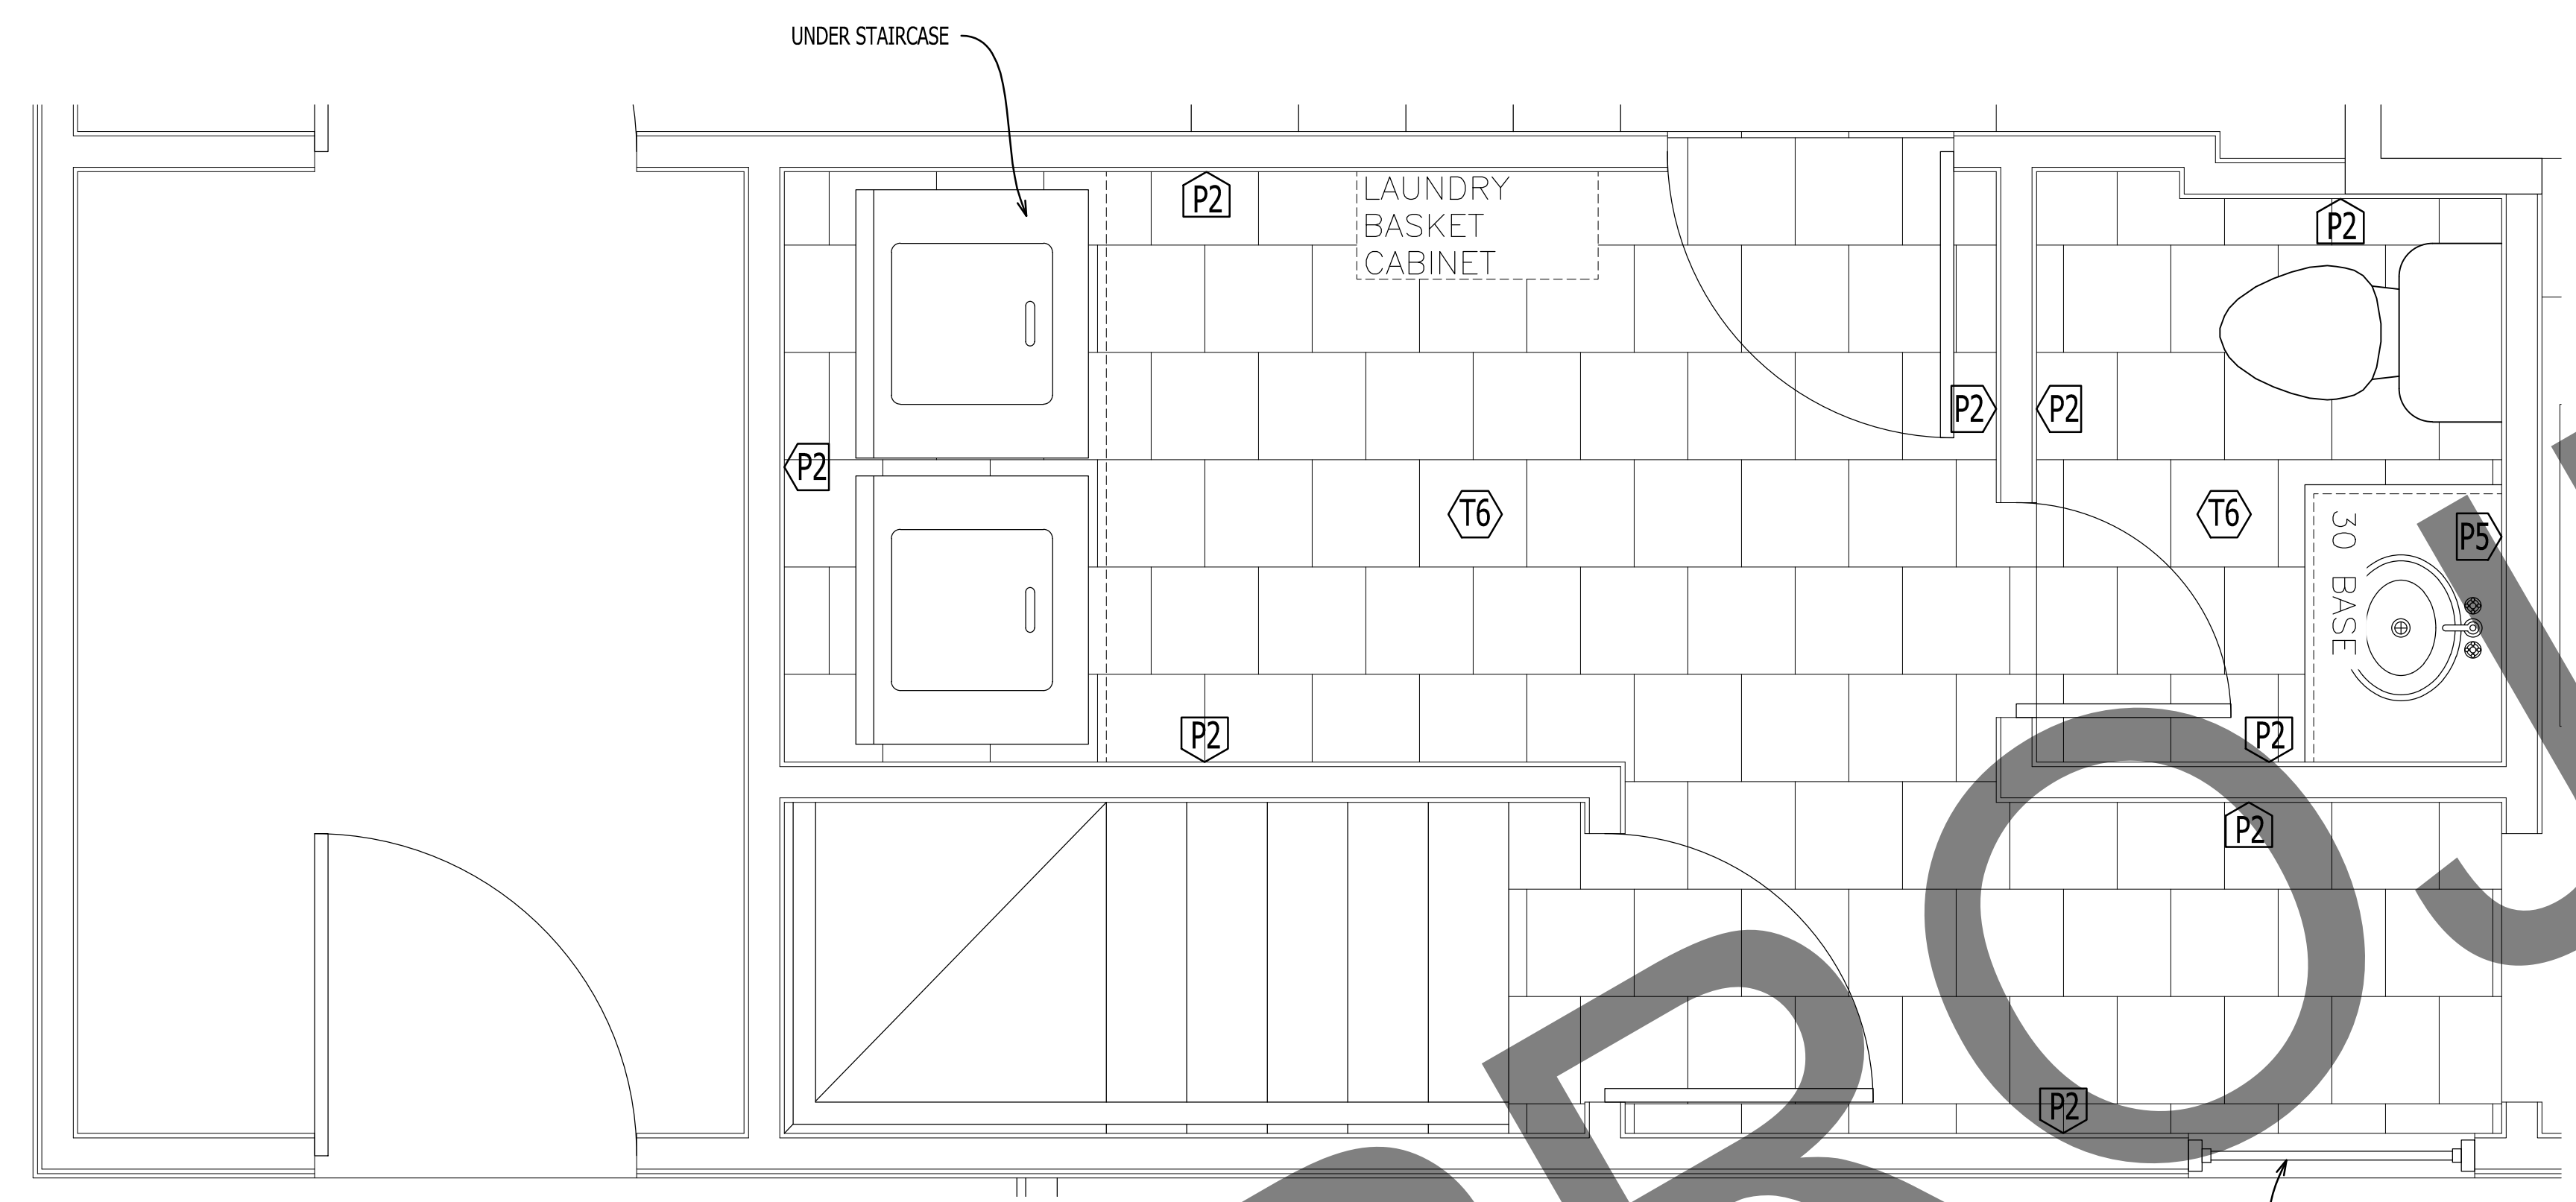


1
A-301 LAUNDRY ROOM ENLARGED PLAN
Scale: 3/4" = 1'-0"

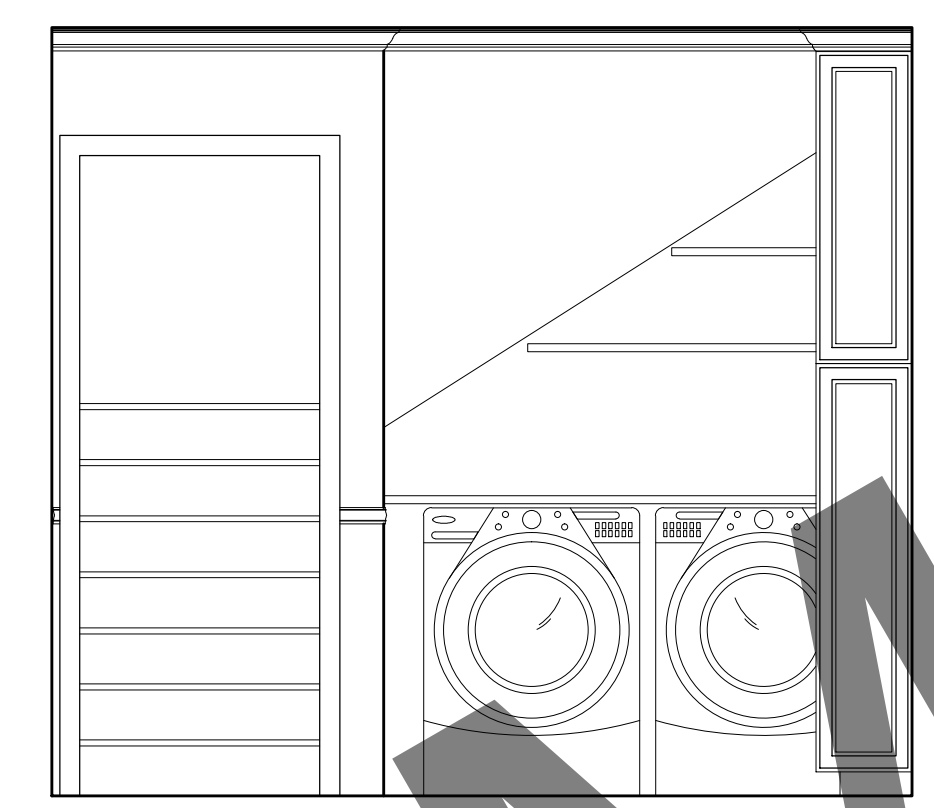


1
A-201 LAUNDRY ELEVATION
Scale: 1/2" = 1'-0"

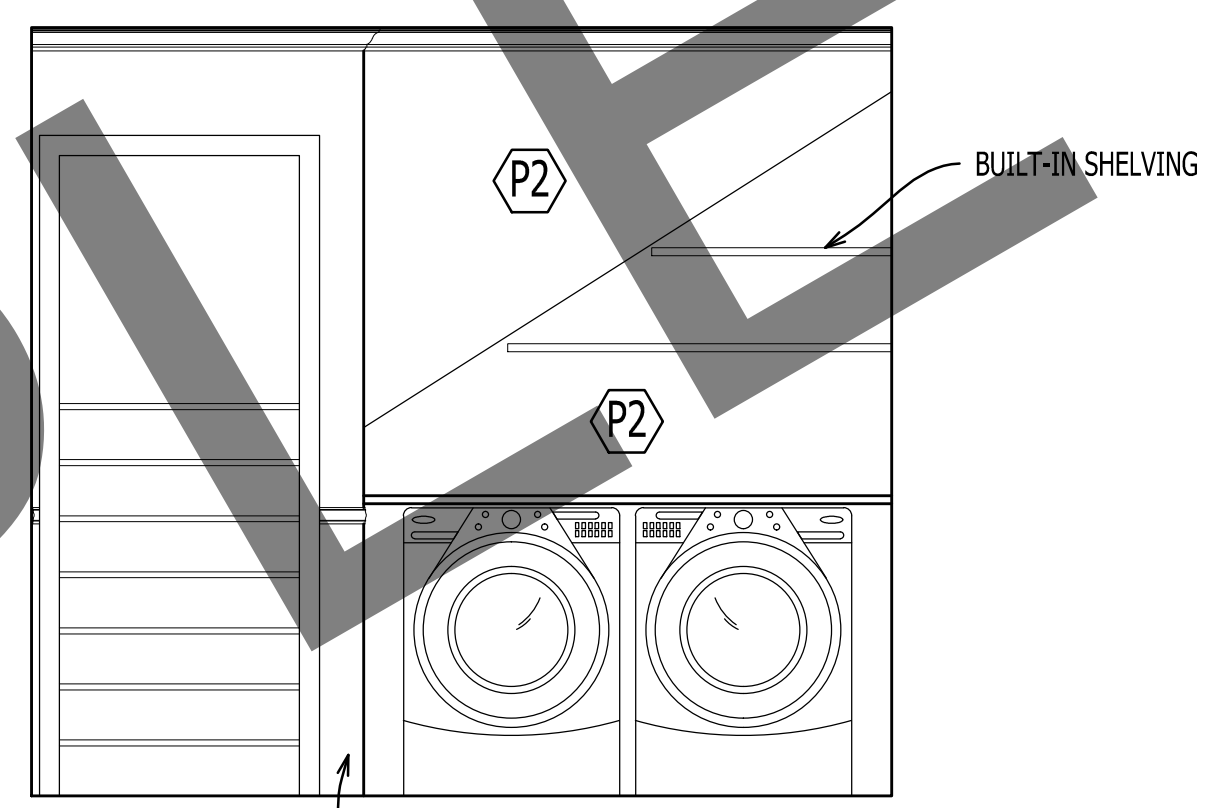



1
A-201 LAUNDRY ELEVATION
Scale: 1/2" = 1'-0"

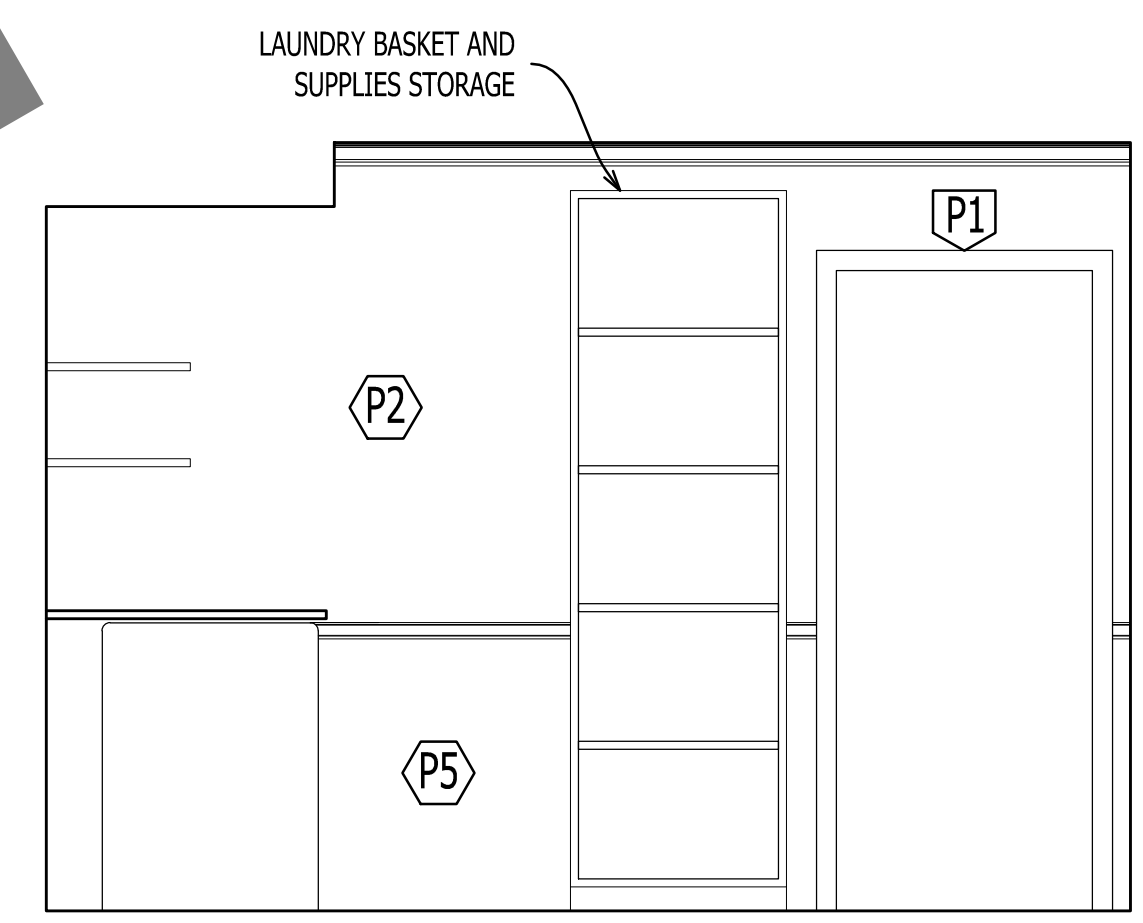


1
A-201 LAUNDRY ELEVATION
Scale: 1/2" = 1'-0"

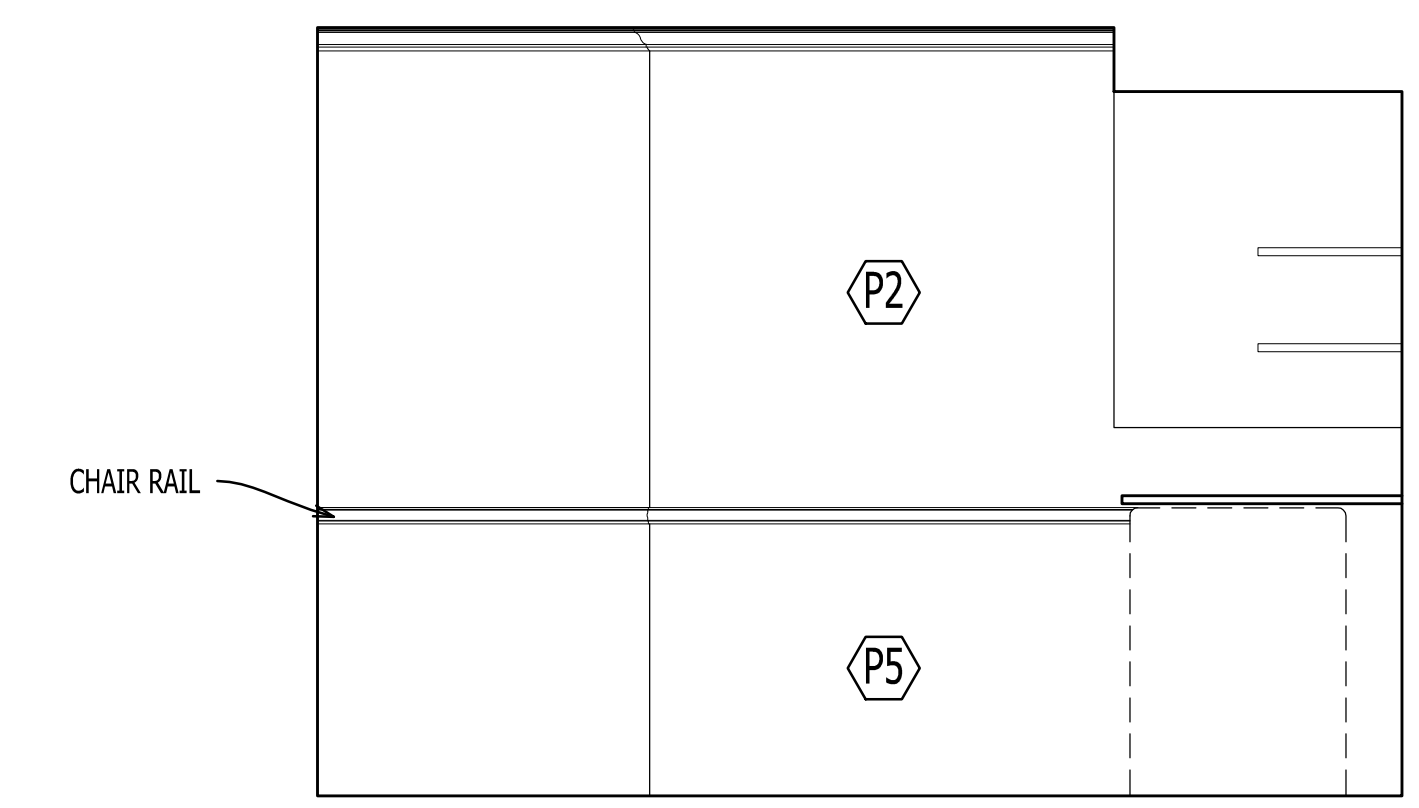


1
A-201 LAUNDRY ELEVATION
Scale: 1/2" = 1'-0"

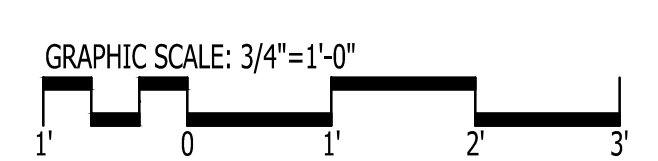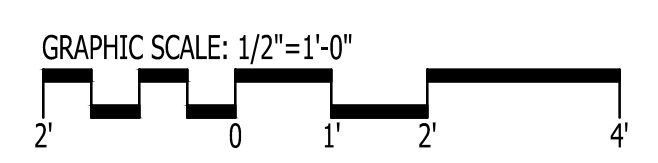

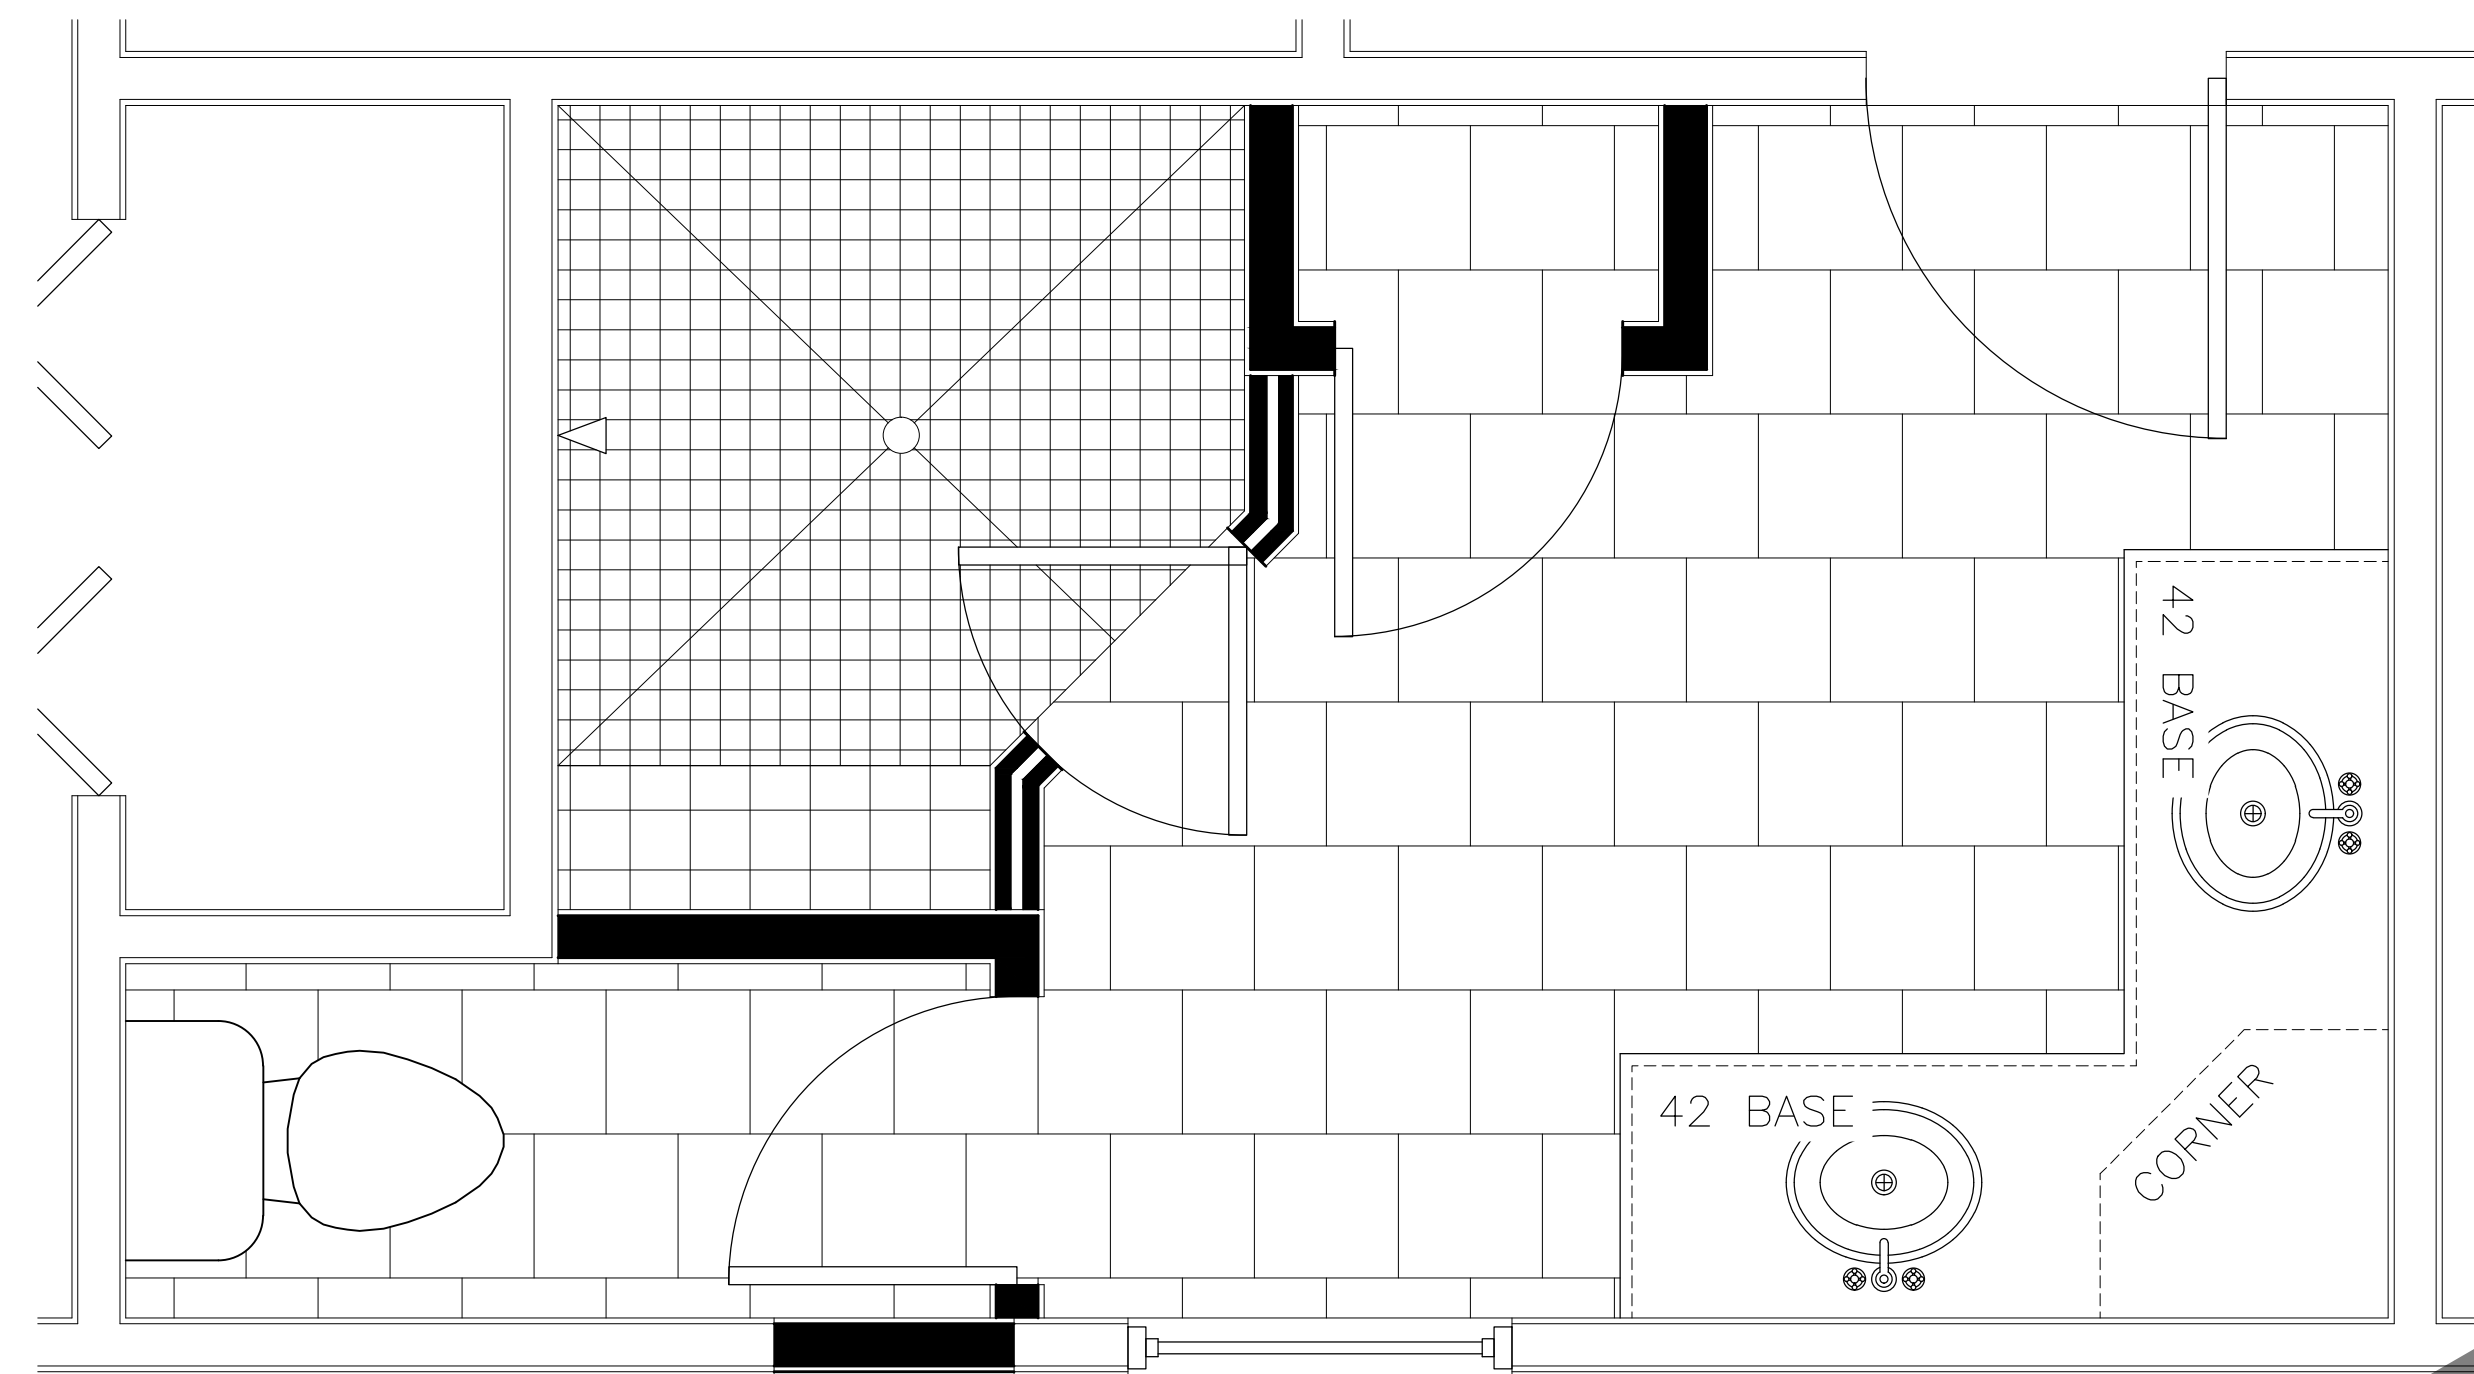

1 MASTER BATHROOM ENLARGED PLAN
A-301 Scale: 3/4" = 1'-0"

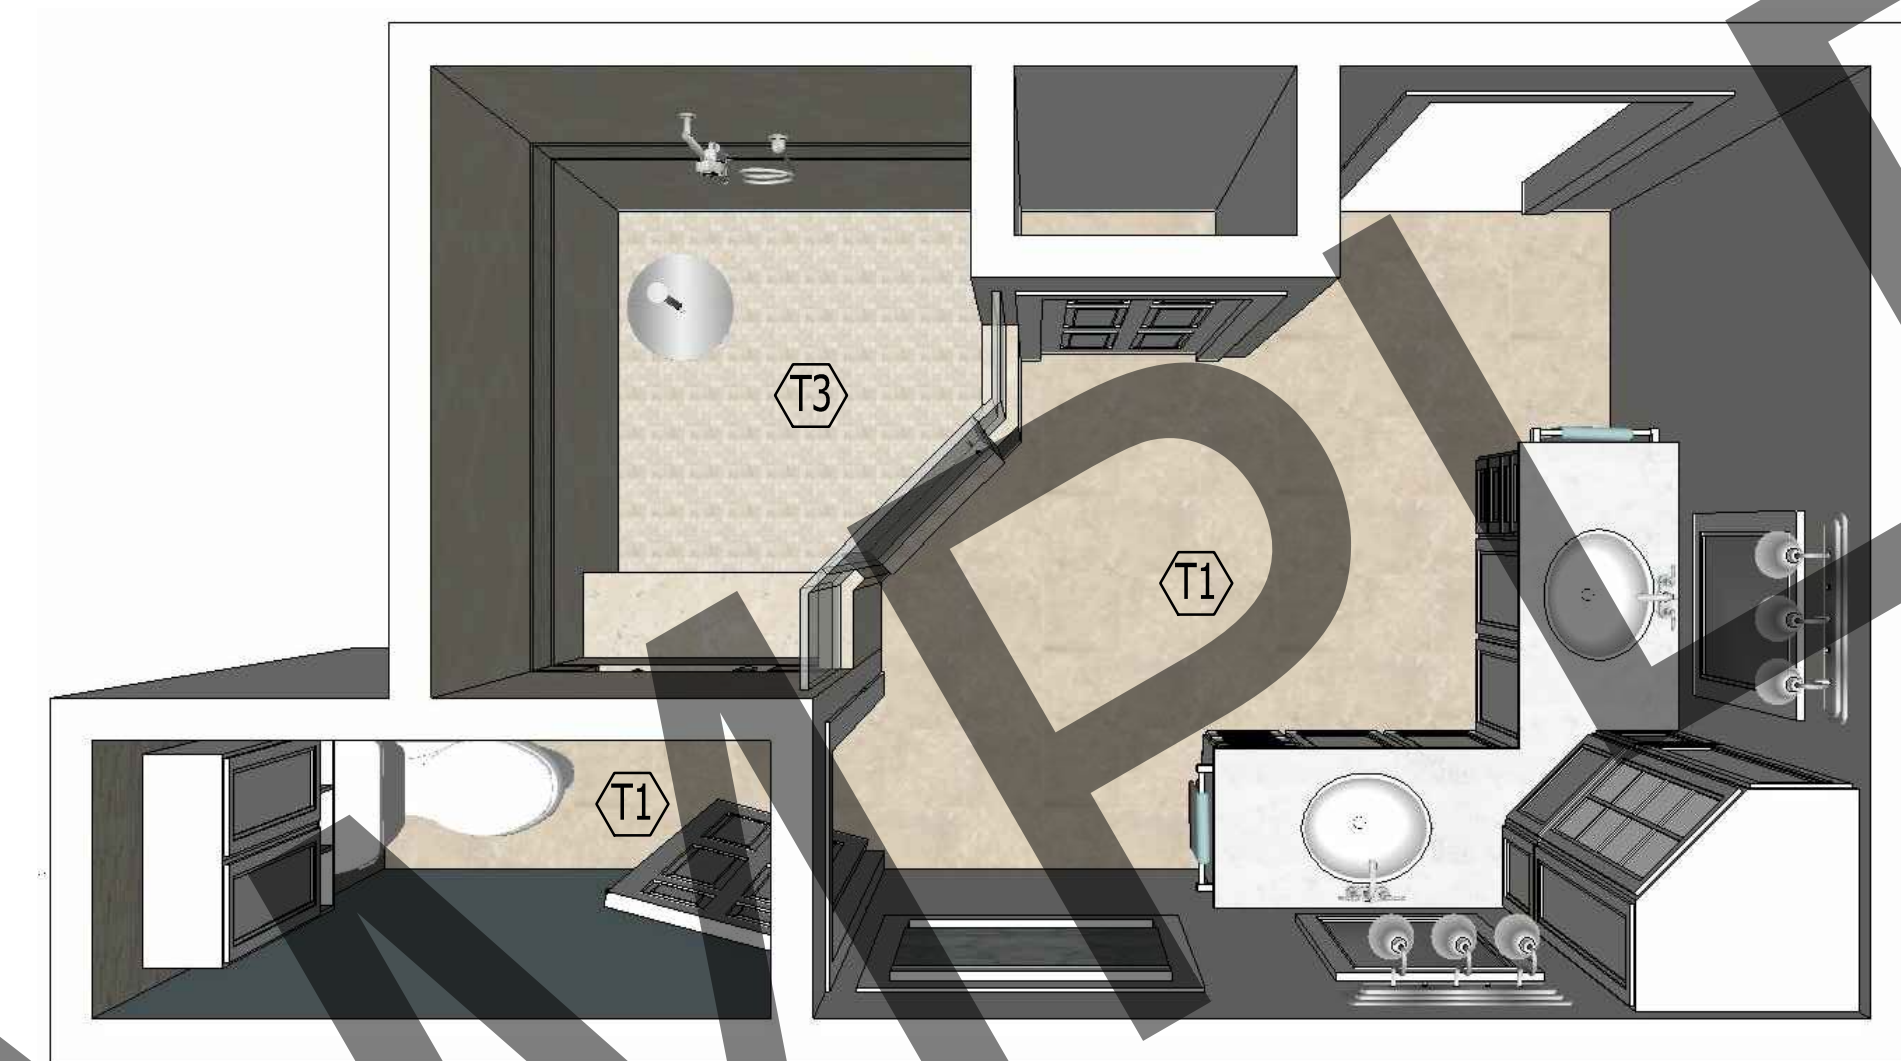

2 MASTER BATHROOM RENDERING
A-301 No Scale




3 MASTER BATHROOM RENDERING
A-301 No Scale



4 MASTER BATHROOM RENDERING
A-301 No Scale



5 MASTER BATHROOM RENDERING
A-301 No Scale

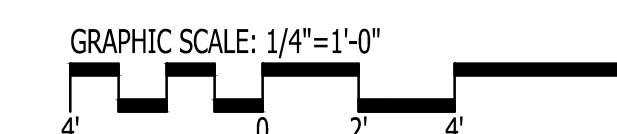


COPYRIGHT NOTE:
THESE PLANS ARE THE PROPERTY OF THE ARCHITECT. THESE PLANS CONTAIN PROPRIETARY INFORMATION OF GO ARCHITECTURAL DESIGN, PLLC. THEY ARE SUBJECT TO FEDERAL COPYRIGHT AND OTHER APPLICABLE FEDERAL AND STATE PROPERTY, TRADE AND RELATED LAWS. THESE PLANS, INCLUDING THE INFORMATION CONTAINED WITHIN, SHALL NOT BE SHARED, REPRODUCED, DISTRIBUTED OR USED IN ANY WAY WITHOUT WRITTEN CONSENT FROM THE ARCHITECT. ANY FAILURE TO OBTAIN SUCH CONSENT IS A VIOLATION OF LAW AND MAY BE SUBJECT TO CIVIL AND CRIMINAL PROSECUTION AND PENALTIES.

Date: 05.13.2016
Revisions:


RESIDENCE
NEW BERN, NC 28560

A-301
RENDERINGS
12 X 18 SHEETS ARE HALF SIZE

GO ARCHITECTURAL DESIGN, PLLC
1202-A Pollock St., New Bern, NC 28560
(252)633-0322 Tel www.GOarchdesign.com

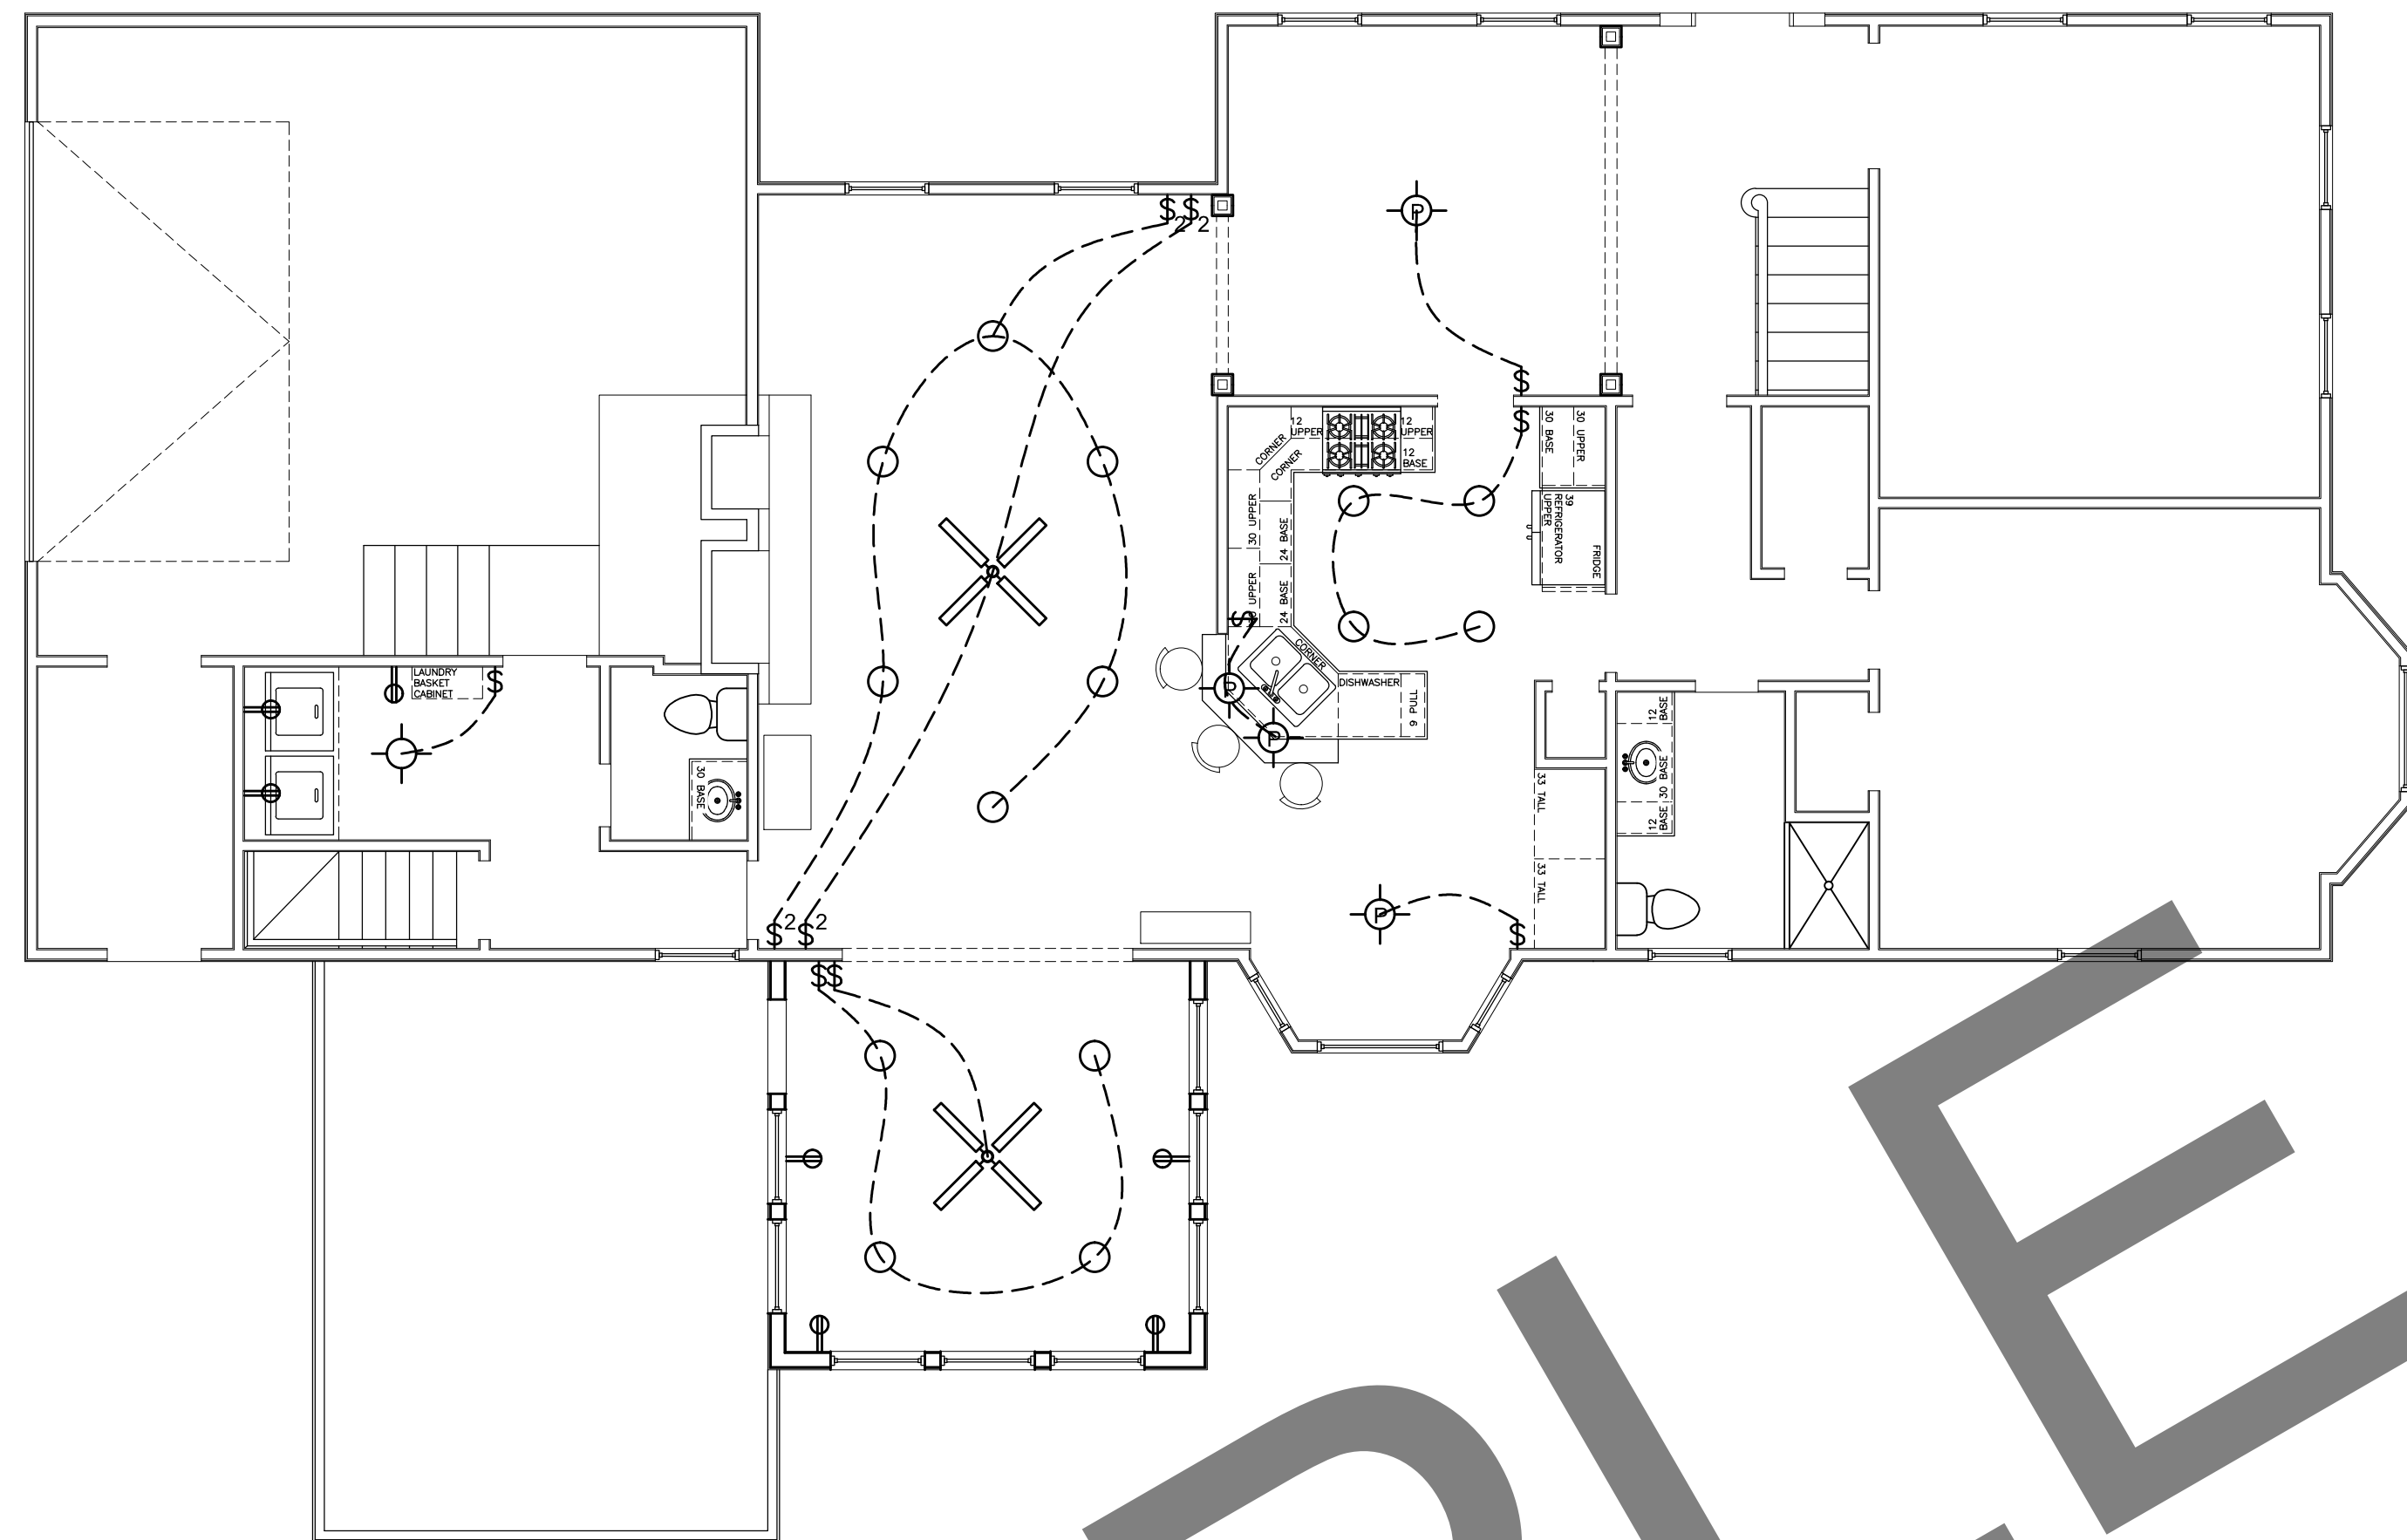

1
A-401
FIRST FLOOR ELECTRICAL PLAN
Scale: 3/16" = 1'-0"

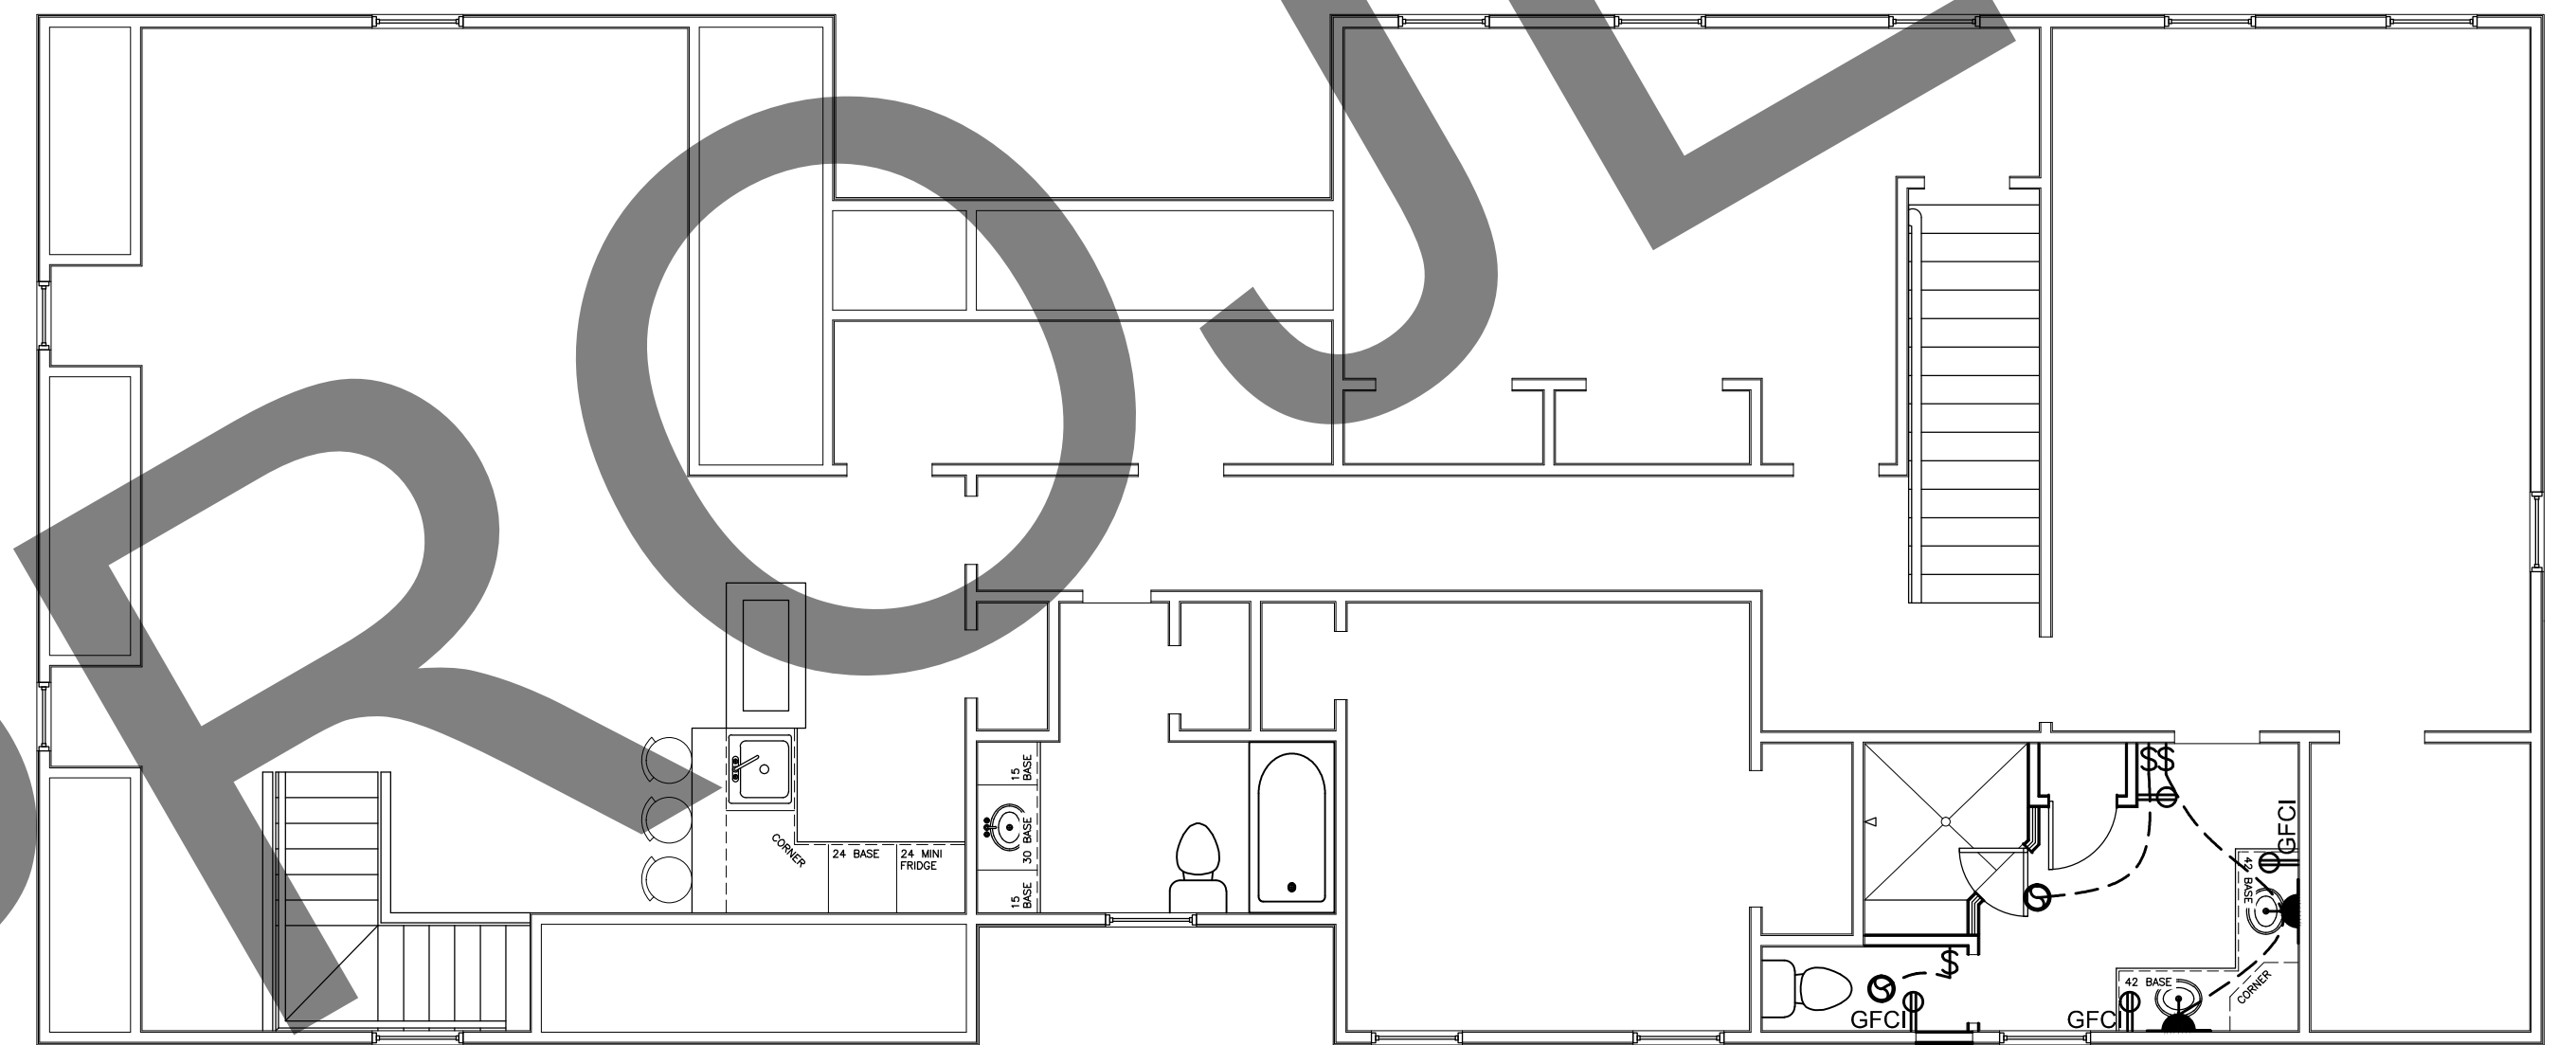

2
A-401
SECOND FLOOR ELECTRICAL PLAN
Scale: 3/16" = 1'-0"

COPYRIGHT NOTE:
 THESE PLANS ARE THE PROPERTY OF THE ARCHITECT.
 THESE PLANS CONTAIN PROPRIETARY INFORMATION OF
 GO ARCHITECTURAL DESIGN, PLLC. THEY ARE SUBJECT
 TO FEDERAL COPYRIGHT AND OTHER APPLICABLE
 FEDERAL AND STATE PROPERTY, TRADE AND RELATED
 LAWS. THESE PLANS, INCLUDING THE INFORMATION
 CONTAINED WITHIN, SHALL NOT BE SHARED,
 REPRODUCED, DISTRIBUTED OR USED IN ANY WAY
 WITHOUT WRITTEN CONSENT FROM THE ARCHITECT.
 ANY FAILURE TO OBTAIN SUCH CONSENT IS A VIOLATION
 OF LAW AND MAY BE SUBJECT TO CIVIL AND CRIMINAL
 PROSECUTION AND PENALTIES.

Date: 05.13.2016
 Revisions:

RESIDENCE
 NEW BERN, NC 28560

A-401
 ELECTRICAL PLAN
 12 X 18 SHEETS ARE HALF SIZE

**GO ARCHITECTURAL
 DESIGN, PLLC**
 1202-A Pollock St., New Bern, NC 28560
 (252)633-0322 Tel www.GOarchdesign.com